



BIRD GIBSON SPORTS CENTER

599 SOUTH TABORTOWN ROAD

TERRE HAUTE, INDIANA 47803

2026 BUILDING REMODEL PHASE 1



OWNER:



WABASH VALLEY FAMILY SPORTS CENTER


599 SOUTH TABORTOWN ROAD
TERRRE HAUTE, INDIANA 47803
(812)234-3333
CONTACT: MRS. KAREN DYER,
BOARD MEMBER
KAREN@TERREHAUTE.COM

ENGINEER:




MICHAEL R. WALDBIESER ENGINEERING & CONSULTING, INC.

19 SOUTH 6TH STREET, SUITE 804
TERRE HAUTE, INDIANA 47807
(812) 232-6510
CONTACT: MR. MICHAEL R. WALDBIESER, PE
michael@mrwengineeringinc.com

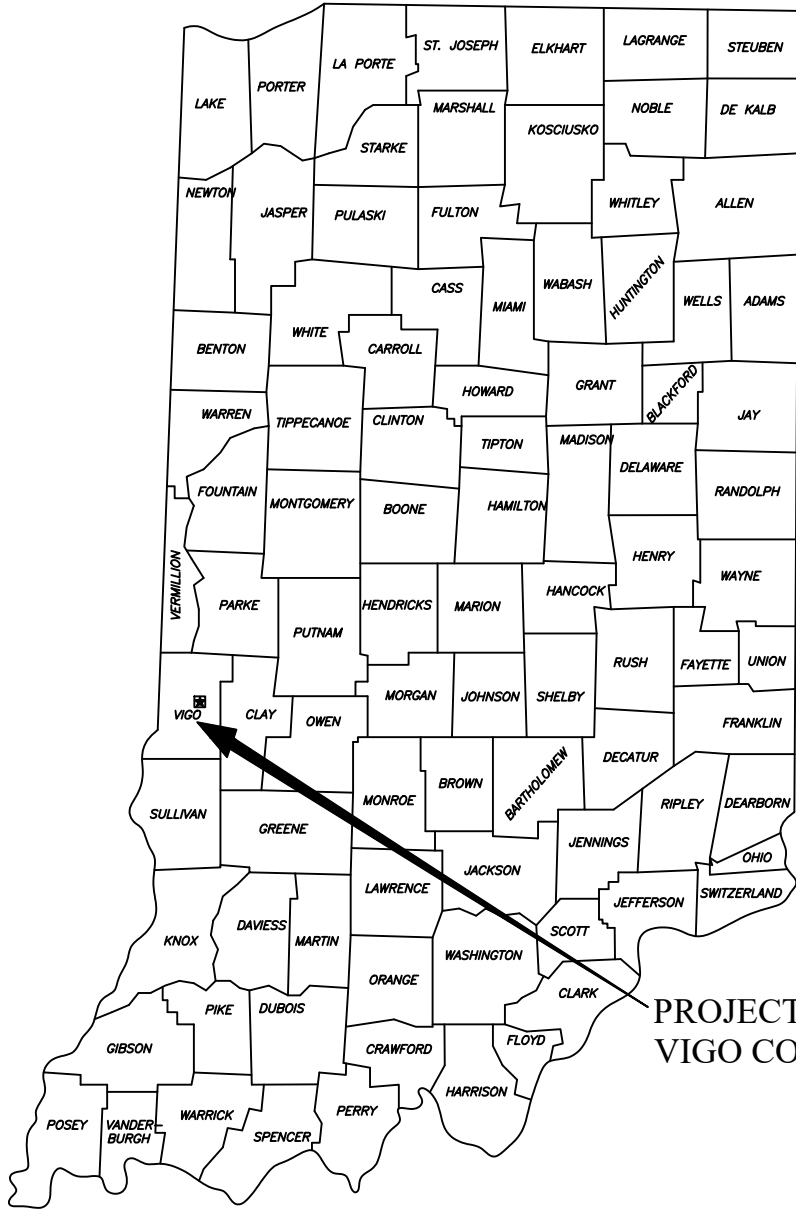

AREA LOCATION MAP - STATE OF INDIANA

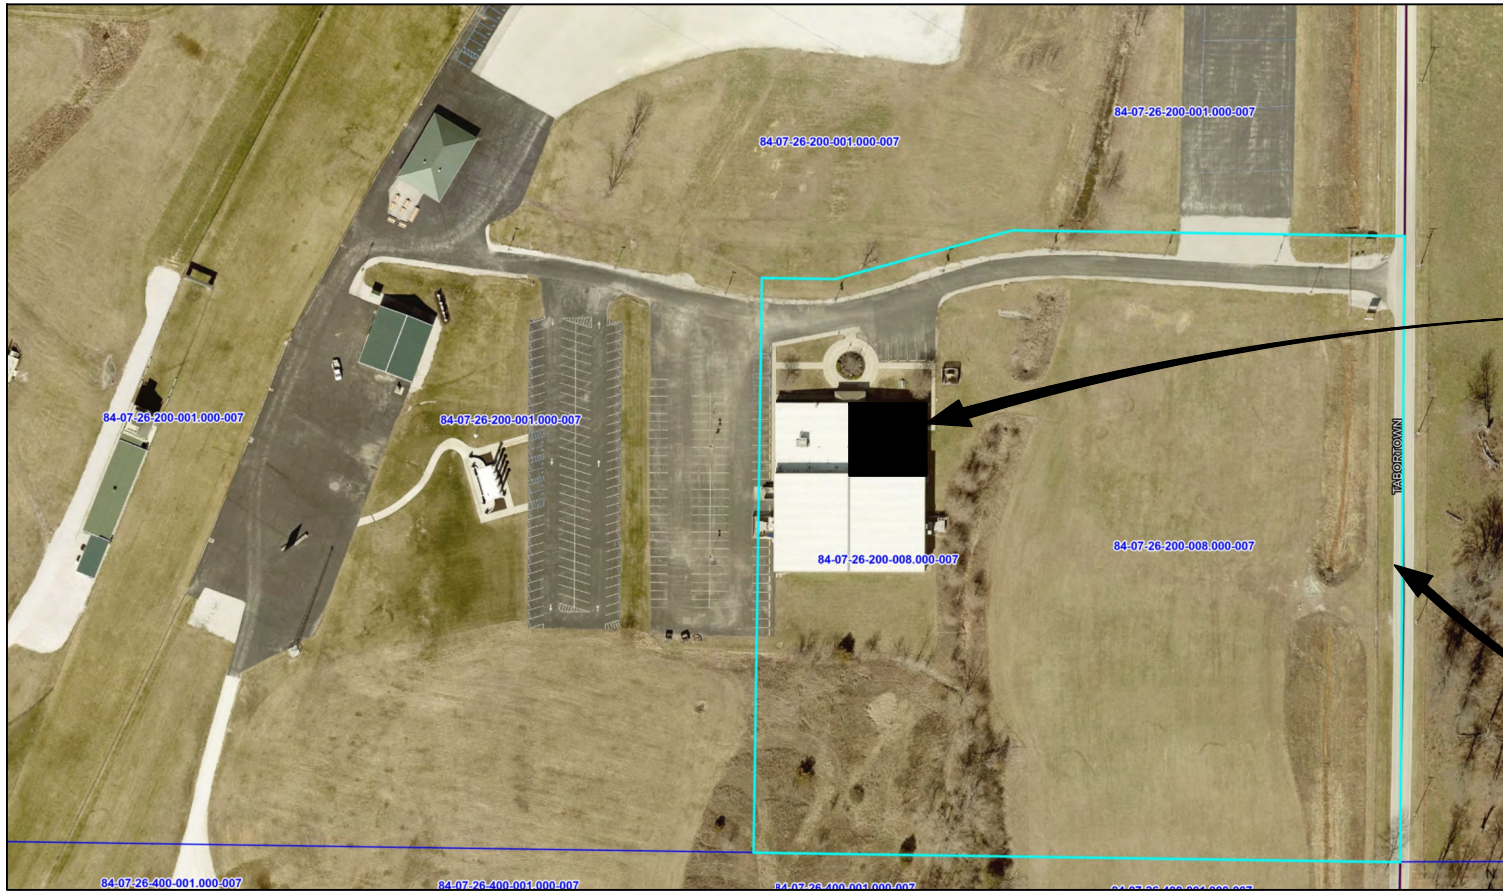

SYMBOL LEGEND		ABBREVIATIONS			
+100.00	EXISTING SITE GRADE ELEVATION	A/C	Air Conditioner	HC	Hollow Core
100'-0"	NEW SITE GRADE ELEVATION	ADD	Addendum	HD	Head
SECT. NO.	SECTION CUT	ADI	Adjacent	HDR	Header
DWG. NO.	INTERIOR ELEVATION DETAIL	ALT	Alternate	HDWR	Hardware
DETAIL NO.	DETAIL MARK	Alum	Aluminum	HM	Hollow Metal
DWG. NO.	ELEVATION MARK	ANOD	Anodized	HORIZ	Horizontal
WALL PARTITION TYPE	WALL PARTITION TYPE	ARCH	Architectural	HT	Height
DOOR NUMBER	DOOR NUMBER	BD	Board	HTG	Heater
WINDOW CALL OUT	WINDOW CALL OUT	BLDG	Building	HVAC	Heating, Venting and Air Conditioning
ROOM NAME AND NUMBER	ROOM NAME AND NUMBER	BLK	Block	INCL	Include
NEW DOOR	NEW DOOR	BM	Benchmark	INS	Insulation
EXISTING DOOR	EXISTING DOOR	BM	Beam	INT	Interior
PLAN OR NUMBERED NOTE	PLAN OR NUMBERED NOTE	BO	Bottom Of	JST	Joist
DEMOLITION PLAN NOTE	DEMOLITION PLAN NOTE	BOTT	Bottom Of Steel	JT	Joint
		BRG	Bearing	LAM	Laminated
		BSMT	Basement	LAV	Lavatory
		BTU	British Thermal Unit	LP	Light/Utility Pole
		CJ	Control Joint	LVR	Lever
		CLG	Ceiling	LW	Light Weight
		CL	Center Line	MAX	Maximum
		CLR	Clear	MECH	Mechanical
		CMU	Concrete Masonry Unit	MFR	Manufacturer
		CO	Clean Out	MIN	Minimum
		Col	Column	MISC	Miscellaneous
		CONC	Concrete	MO	Masonry Opening
		CONST	Construction	MTD	Mounted
		CONT	Continuous	MTL	Metal
		CU	Condensing Unit	NIC	Not In Contract
		CY	Cubic Yard	NO	Number
		DF	Drinking Fountain	NOM	Nominal
		DIA	Diameter	NTS	Not To Scale
		DM	Dimension	OA	Over all
		DS	Down Spout	OC	On Center
		DTL	Detail	OD	Outside Diameter
		DW	Dishwasher	OH	Overhead
		DWG	Drawing	OPNG	Opening
		EA	Each	PL	Property Line
		EIFS	Exterior Insulation and Finish System	PLAM	Plastic Laminate
		EJ	Expansion Joint	PLBG	Plumbing
		ELEC	Electric (sl)	PLYWD	Plywood
		ELEV	Elevator	PP	Power Pole
		EMER	Emergency	PR	Pair
		EQ	Equal	PSF	Pounds per Square Foot
		EW	Each Way	PSI	Pounds per Square Inch
		EXTG	Existing	PVC	Polyvinyl Chloride
		EXP	Expansion	QTY	Quantity
		EXT	Exterior	R	Radius
		FBO	Finished By Others	RA	Return Air
		FD	Floor Drain	RD	Roof Drain
		FEC	Fire Extinguisher and Cabinet	REF	Recessed
		FF	Finished Floor	REFL	Reflected
		FIN	Finished	REINF	Reinforced
		FLR	Floor	REQD	Required
		FND	Foundation	REV	Revision
		FT	Foot	RM	Room
		FTG	Footing	RO	Rough Opening
		GA	Gauge	RTU	Roof Top Unit
		GALV	Galvanized	SA	Supply Air
		GB	Grab Bar	SS	Sanitary Sewer
		GC	General Contractor	SC	Solid Core
		GYP BD	Gypsum Board	SCH	Schedule

TITLE SHEET

2524-T1 COVER/TITLE SHEET
2524-1.0 ENTIRE EXISTING BUILDING FLOOR PLAN
2524-1.1 EXISTING/DEMOLITION FLOOR PLAN
2524-1.2 NEW FLOOR PLAN/
ROOM FINISH AND DOOR SCHEDULE
2524-2.0 EXISTING/DEMOLITION REFLECTIVE CEILING PLAN
2524-2.1 NEW REFLECTIVE CEILING PLAN
2524-3.0 HANDICAPPED ACCESSORY PLAN

2524-P1.0 PLUMBING PLANS
2524-P2.0 PLUMBING SPECIFICATIONS

2524-M1.0 MECHANICAL PLANS

2524-E1.0 ELECTRICAL POWER/LIGHTING PLANS
2524-E2.0 ELECTRICAL SPECIFICATIONS

JOB INFORMATION:

GENERAL

BID TYPE: SINGLE PRIME
BID OPENING: PRIVATE
CERTIFIED PAYROLL: NOT REQUIRED
INDIANA SALES TAX: NOT INCLUDED

BONDS , PERMITS, AND INSURANCE

BID BOND: NOT REQUIRED
PERFORMANCE BOND: NOT REQUIRED
LOCAL BUILDING PERMITS: BY EACH CONTRACTOR FOR THEIR WORK
STATE BUILDING PERMIT: NOT REQUIRED ON THIS PROJECT
BUILDERS RISK POLICY: BY OWNER (INCLUDING POLICY DEDUCTIBLE)

UTILITY COST DURING CONSTRUCTION

ELECTRICITY: BY OWNER
CHORDS AND CONNECTIONS BY
GENERAL CONTRACTOR
WATER: BY OWNER
CONNECTION DURING CONSTRUCTION BY
GENERAL CONTRACTOR
NATURAL GAS: NOT ON THIS PROJECT

SOIL AND CONCRETE TESTING:

CONCRETE: NOT REQUIRED
SOIL: NOT REQUIRED

FIRE EXTINGUISHERS:

PROVIDED AND INSTALLED BY GENERAL CONTRACTOR.
LOCATIONS AS DIRECTED BY LOCAL FIRE DEPARTMENT.

GOVERNING CODES


2014 INDIANA BUILDING CODE
(IBC 2012 EDITION - WITH INDIANA AMENDMENTS)
2014 INDIANA FIRE CODE
(IFC 2012 EDITION - WITH INDIANA AMENDMENTS)
2012 INDIANA PLUMBING CODE
(IPC 2006 EDITION - WITH INDIANA AMENDMENTS)
2014 INDIANA MECHANICAL CODE
(IMC 2012 EDITION - WITH INDIANA AMENDMENTS)
2010 INDIANA ENERGY CONSERVATION CODE
(ANSI/ASHRAE 90.1 - 2007 EDITION - WITH INDIANA AMENDMENTS)
2009 INDIANA ELECTRICAL CODE
(NEC 2008 EDITION - WITH INDIANA AMENDMENTS)

DATE	REVISIONS	BY



SCALE: NONE	DATE: 07-13-26	DRAWN BY: MRW	APPROVED BY: MRW
-------------	----------------	---------------	------------------

PROJECT: 25-24
FILE: Cover #F

T1

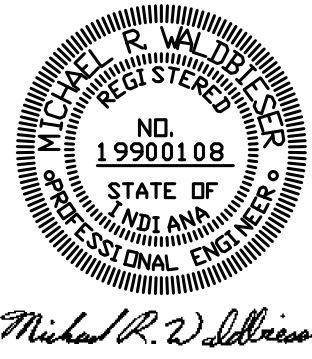

THE CONTENTS OF THIS DOCUMENT ARE THE SOLE PROPERTY OF MICHAEL R. WALDBIESER ENGINEERING & CONSULTING, INC. AND MAY NOT BE REPRODUCED OR TRANSFERRED IN ANY WAY WITHOUT THE WRITTEN CONSENT OF MICHAEL R. WALDBIESER ENGINEERING & CONSULTING, INC. ALL REPORTS, PLANS, SPECIFICATIONS, COMPUTER FILES, FIELD DATA, NOTES, AND OTHER DOCUMENTS AND INSTRUMENTS PREPARED BY MICHAEL R. WALDBIESER ENGINEERING & CONSULTING, INC. (DESIGN PROFESSIONAL) AS INSTRUMENTS OF SERVICE SHALL REMAIN THE PROPERTY OF MICHAEL R. WALDBIESER ENGINEERING & CONSULTING, INC. MICHAEL R. WALDBIESER ENGINEERING & CONSULTING, INC. SHALL RETAIN ALL COMMON LAW, STATUTORY, AND OTHER RESERVED RIGHTS, INCLUDING THE COPYRIGHT THEREON. THIS STATEMENT SHALL NOT BE REMOVED FROM THIS DRAWING FOR ANY REASON.

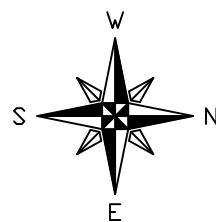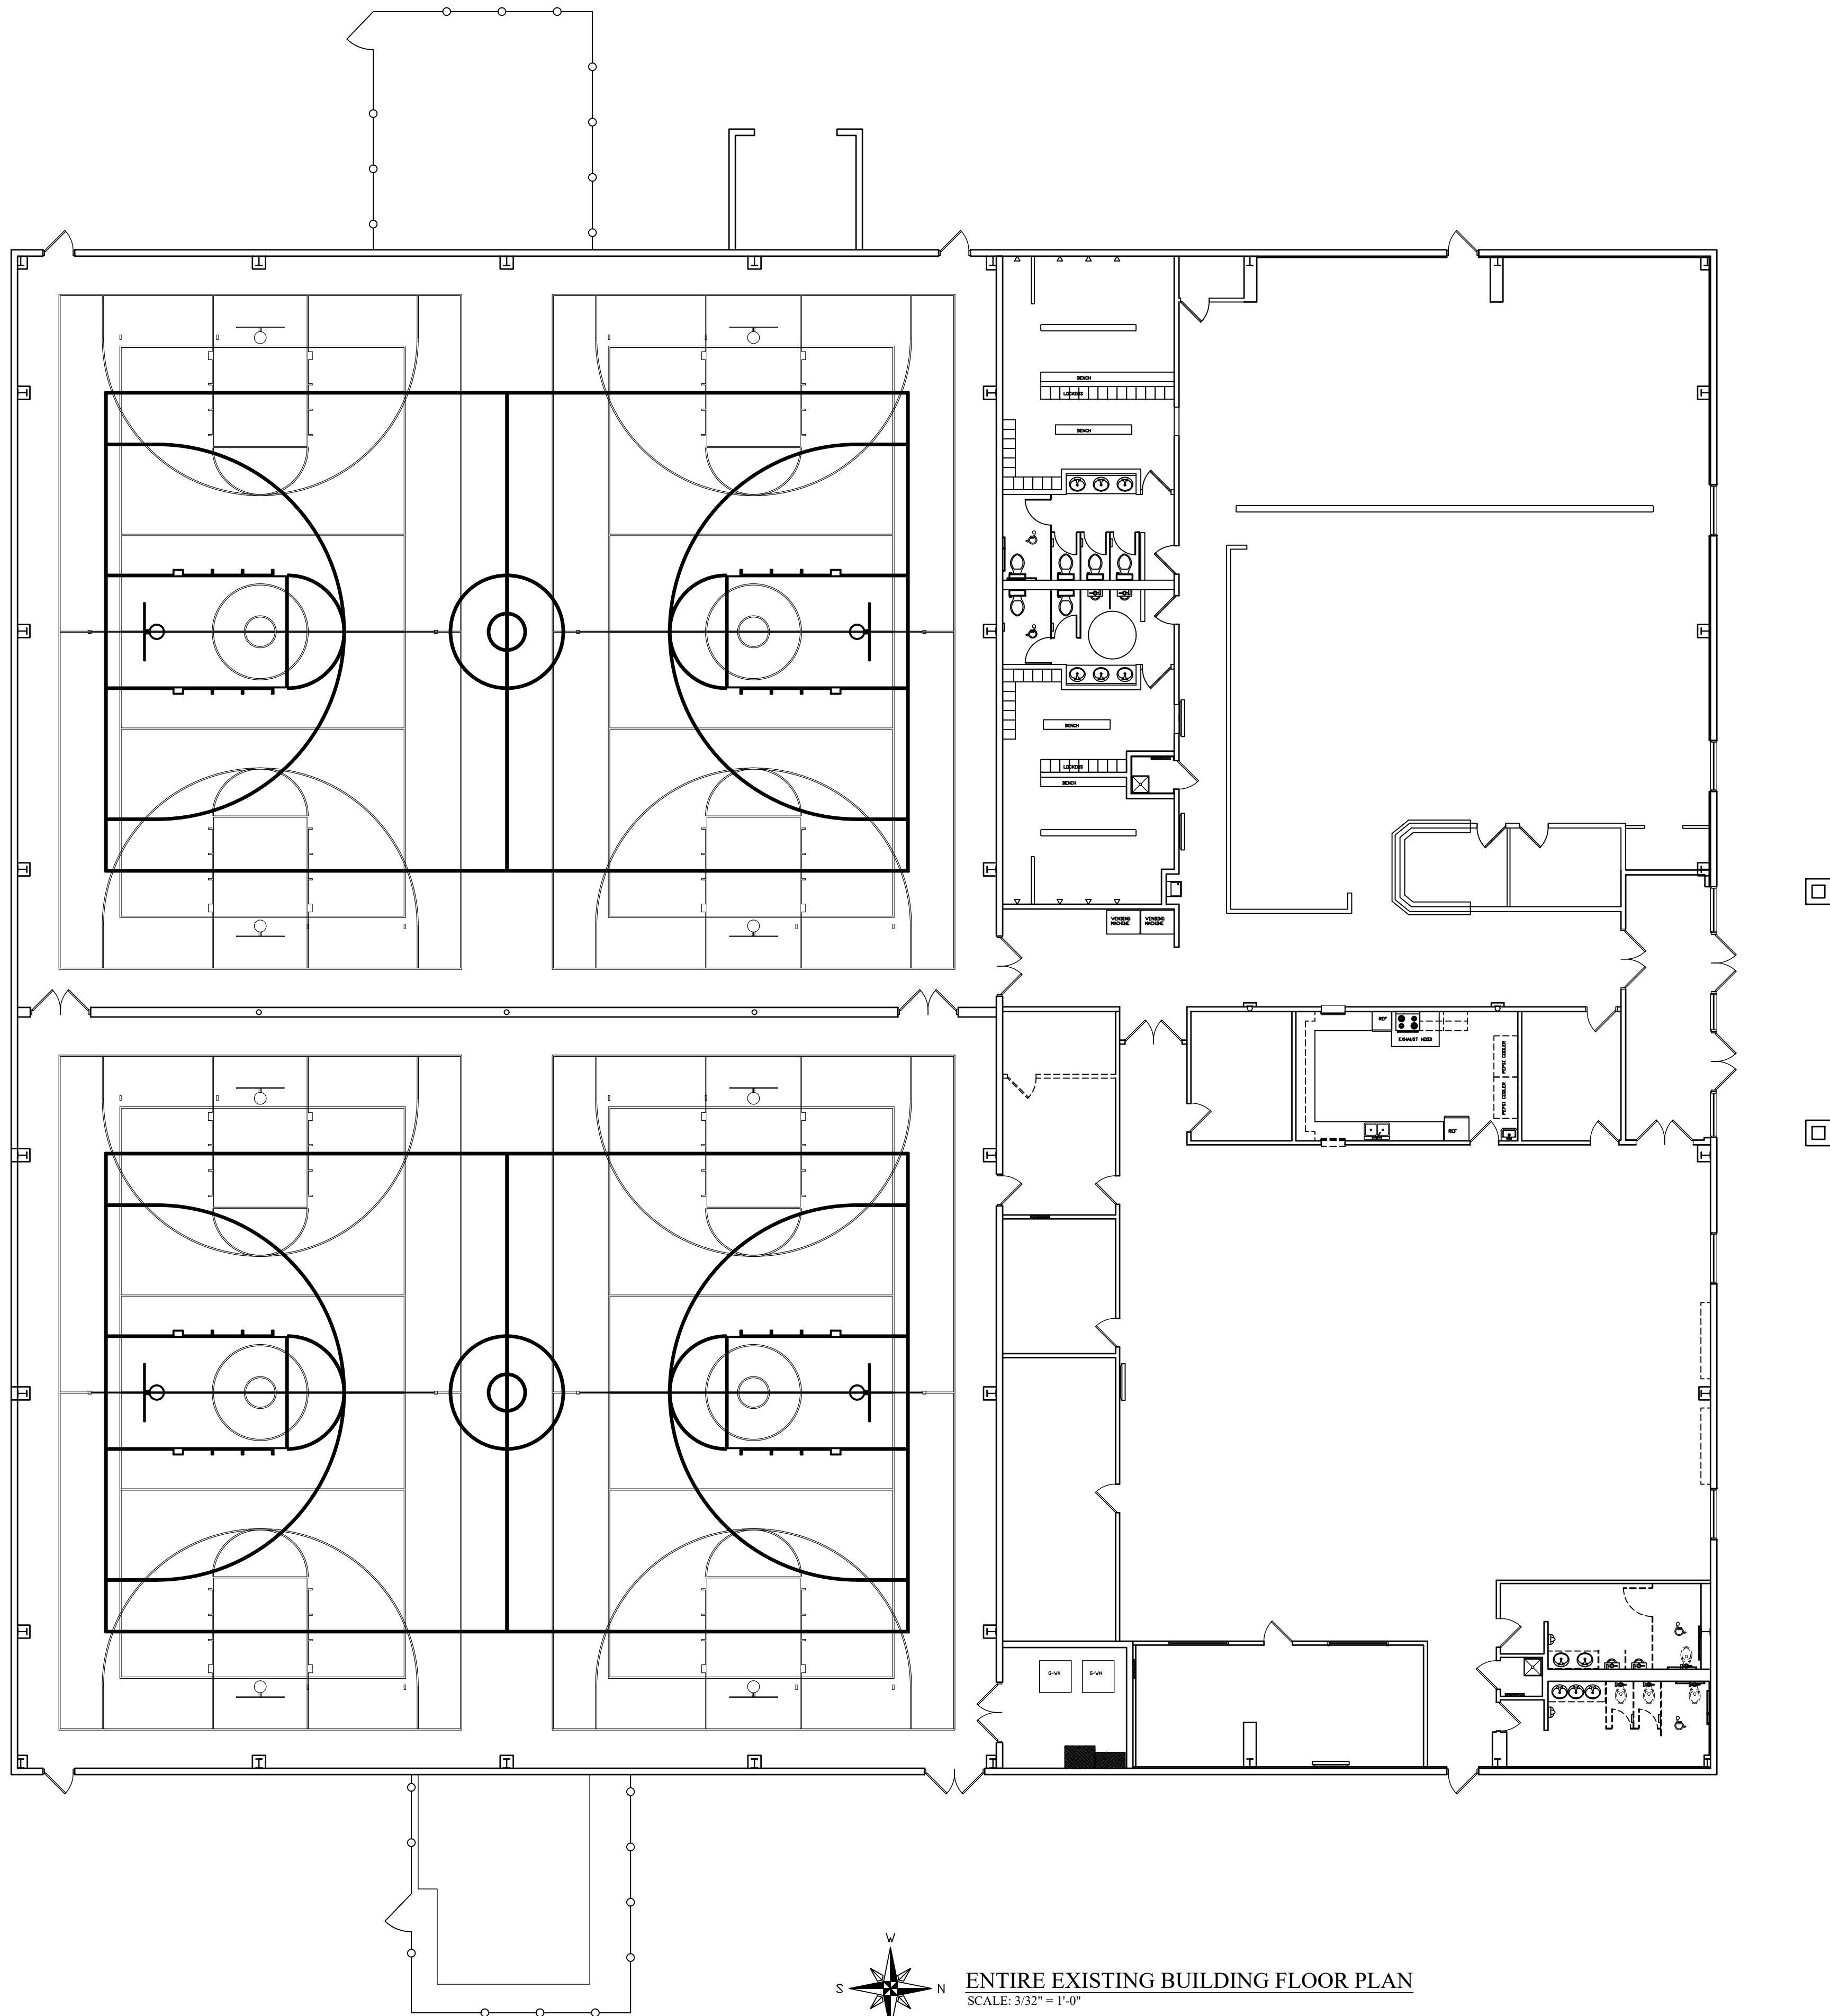

ENTIRE EXISTING BUILDING FLOOR PLAN
SCALE: 3/32" = 1'-0"

THE CONTENTS OF THIS DOCUMENT ARE THE SOLE PROPERTY OF
MICHAEL R. WALDBIESER ENGINEERING & CONSULTING, INC.
AND MAY NOT BE REPRODUCED OR TRANSFERRED IN ANY WAY
WITHOUT THE WRITTEN CONSENT OF MICHAEL R. WALDBIESER
ENGINEERING & CONSULTING, INC.
ALL REPORTS, PLANS, SPECIFICATIONS, COMPUTER FILES, FIELD
DATA, NOTES, AND OTHER DOCUMENTS AND INSTRUMENTS
PREPARED BY MICHAEL R. WALDBIESER ENGINEERING &
CONSULTING, INC. (DESIGN PROFESSIONAL) AS INSTRUMENTS OF
SERVICE SHALL REMAIN THE PROPERTY OF MICHAEL R.
WALDBIESER ENGINEERING & CONSULTING, INC. MICHAEL R.
WALDBIESER ENGINEERING & CONSULTING, INC. SHALL RETAIN
ALL COMMON LAW, STATUTORY, AND OTHER RESERVED RIGHTS,
INCLUDING THE COPYRIGHT THEREO. THIS STATEMENT SHALL
NOT BE REMOVED FROM THIS DRAWING FOR ANY REASON.

SCALE: 3/32" = 1'-0"
DATE: 07-13-26
DRAWN BY: WCF
APPROVED BY: MRW

PROJECT: 25-24
FILE: Model #F

1.0


MICHAEL R. WALDBIESER
ENGINEER & CONSULTING, INC.
STRUCTURAL, REMODELING, MECHANICAL & ELECTRICAL DESIGN
SYCAMORE BUILDING
19 SOUTH 66th STREET, SUITE 804
TERRE HAUTE, INDIANA 47807
PHONE: (812) 232-6510



BIRD GIBSON SPORTS CENTER
599 SOUTH TABORTOWN ROAD
TERRE HAUTE, INDIANA 47803
2026 BUILDING REMODEL PHASE 1



DATE	REVISIONS	BY

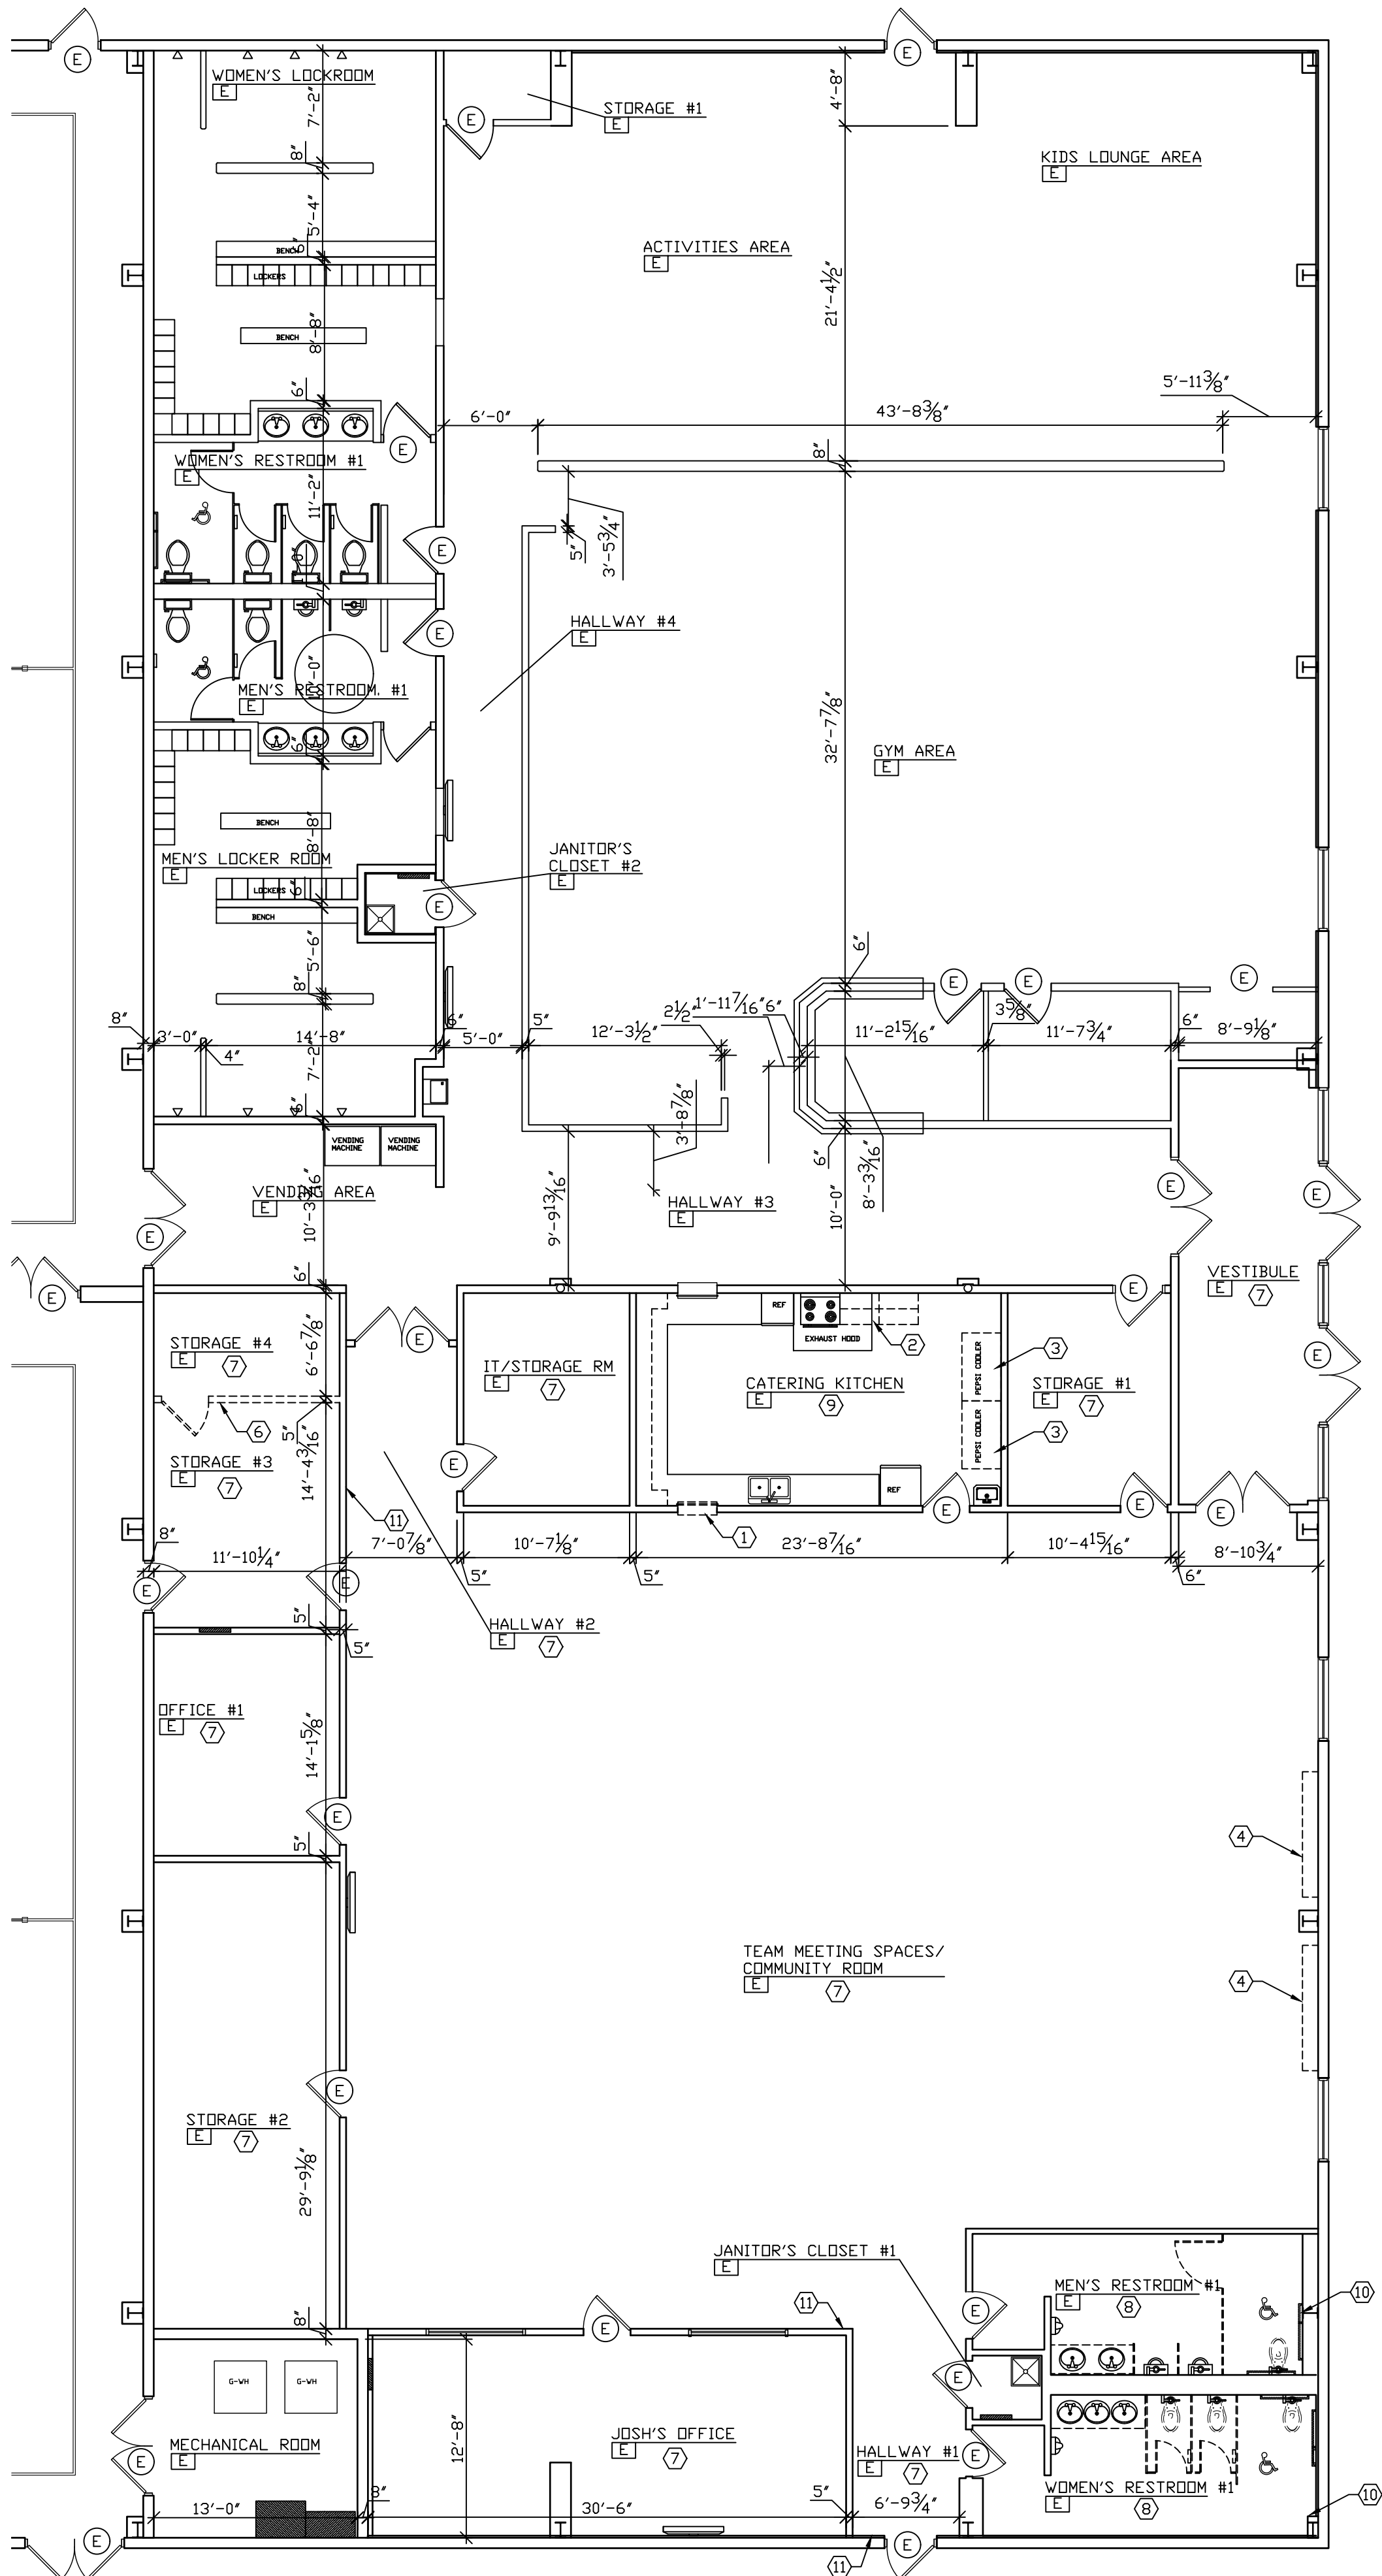

EXISTING/DEMOLITION FLOOR PLAN
SCALE: 1/8" = 1'-0"

NUMBERED NOTES:

1. REMOVE EXISTING SERVING COUNTER COMPLETE. PREPARE OPENING FOR IN-FILL.
2. REMOVE EXISTING BASE CABINETS AND COUNTER COMPLETE. REPAIR WALLS AS REQUIRED FOR PAINTING.
3. EXISTING COOLERS TO BE RELOCATED BY CONTRACTOR TO NEW LOCATIONS INDICATED.
4. REMOVE EXISTING WALL HUNG SHELF COMPLETE. REPAIR WALL AS REQUIRED FOR PAINTING.
5. NDT USED
6. REMOVE EXISTING WALL AND DOOR COMPLETE. REPAIR WALLS TO REMAIN AS REQUIRED.
7. REMOVE EXISTING ACCOUSTICAL CEILING AND GRID COMPLETE IN THIS ROOM. REMOVE EXISTING VINYL BASE COMPLETE. REMOVE EXISTING FLOORING COMPLETE. REPAIR EXISTING WALLS AS REQUIRED FOR PAINTING.
8. REMOVE EXISTING ACCOUSTICAL CEILING AND GRID COMPLETE IN THIS ROOM. REMOVE ALL EXISTING WALL TILE AND GYPSUM BOARD COMPLETE. PREPARE FLOOR FOR NEW EPOXY COATING. PREPARE STUDS FOR NEW GYPSUM BOARD. REMOVE EXISTING TOILET PARTITIONS COMPLETE. REMOVE EXISTING COUNTERS COMPLETE.
9. REMOVE EXISTING ACCOUSTICAL CEILING AND GRID COMPLETE IN THIS ROOM. REMOVE EXISTING VINYL BASE COMPLETE. REMOVE EXISTING FLOORING COMPLETE. REPAIR EXISTING WALLS AS REQUIRED FOR PAINTING.
10. REMOVE LOOSE CONCRETE FLOOR. PATCH AS REQUIRED PRIOR TO NEW EPOXY FLOOR BEING INSTALLED.
11. PATCH WALL AS REQUIRED FROM ELECTRICAL SWITCH REMOVAL AND REWORK

GENERAL NOTES:


1. REPAIR ALL WALLS AFTER REMOVAL OF VINYL WALL BASE AS REQUIRED.
2. REPAIR ALL WALLS AFTER REMOVAL OF CEILING GRID AS REQUIRED.
3. REPAIR ALL WALLS AS REQUIRED FROM OLD HOLES AND PICTURES.
4. PREPARE ALL HM STEEL FRAMES AND HM STEEL DOOR AS REQUIRED FOR PANTING.

GENERAL NOTES:

1. ALL FLOOR PLAN DIMENSIONS ARE FROM FACE OF STUD TO FACE OF STUD UNLESS NOTED OTHERWISE.
2. ALL INTERIOR STUDS SHALL BE 3 5/8" IN DEPTH UNLESS NOTED OTHERWISE.

THE CONTENTS OF THIS DOCUMENT ARE THE SOLE PROPERTY OF MICHAEL R. WALDBIESER ENGINEERING & CONSULTING, INC. AND MAY NOT BE REPRODUCED OR TRANSFERRED IN ANY WAY WITHOUT THE WRITTEN CONSENT OF MICHAEL R. WALDBIESER ENGINEERING & CONSULTING, INC. ALL REPORTS, PLANS, SPECIFICATIONS, COMPUTER FILES, FIELD DATA, NOTES, AND OTHER DOCUMENTS AND INSTRUMENTS PREPARED BY MICHAEL R. WALDBIESER ENGINEERING & CONSULTING, INC. (DESIGN PROFESSIONAL) AS INSTRUMENTS OF SERVICE SHALL REMAIN THE PROPERTY OF MICHAEL R. WALDBIESER ENGINEERING & CONSULTING, INC. MICHAEL R. WALDBIESER ENGINEERING & CONSULTING, INC. SHALL RETAIN ALL COMMON LAW, STATUTORY, AND OTHER RESERVED RIGHTS, INCLUDING THE COPYRIGHT THERETO. THIS STATEMENT SHALL NOT BE REMOVED FROM THIS DRAWING FOR ANY REASON.

DATE	REVISIONS	BY

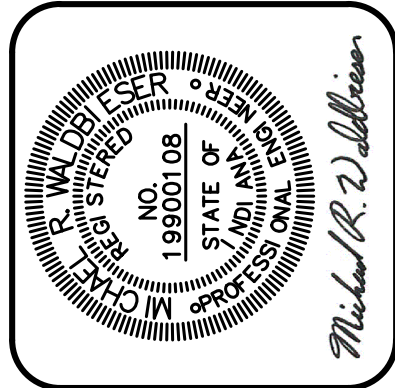


BIRD GIBSON SPORTS CENTER
599 SOUTH TABORTOWN ROAD
TERRE HAUTE, INDIANA 47803
2026 BUILDING REMODEL PHASE 1

MICHAEL R. WALDBIESER
ENGINEER & CONSULTING, INC.
STRUCTURAL, PLUMBING, MECHANICAL & ELECTRICAL
SYCAMORE BUILDING
19 SOUTH 66th STREET, SUITE 804
TERRE HAUTE, INDIANA 47807
PHONE: (812) 232-6510

SCALE: 1/8" = 1'-0"
DATE: 07-13-26
DRAWN BY: WCF
APPROVED BY: MRW

PROJECT: 25-24
FILE: Model #F

1.1

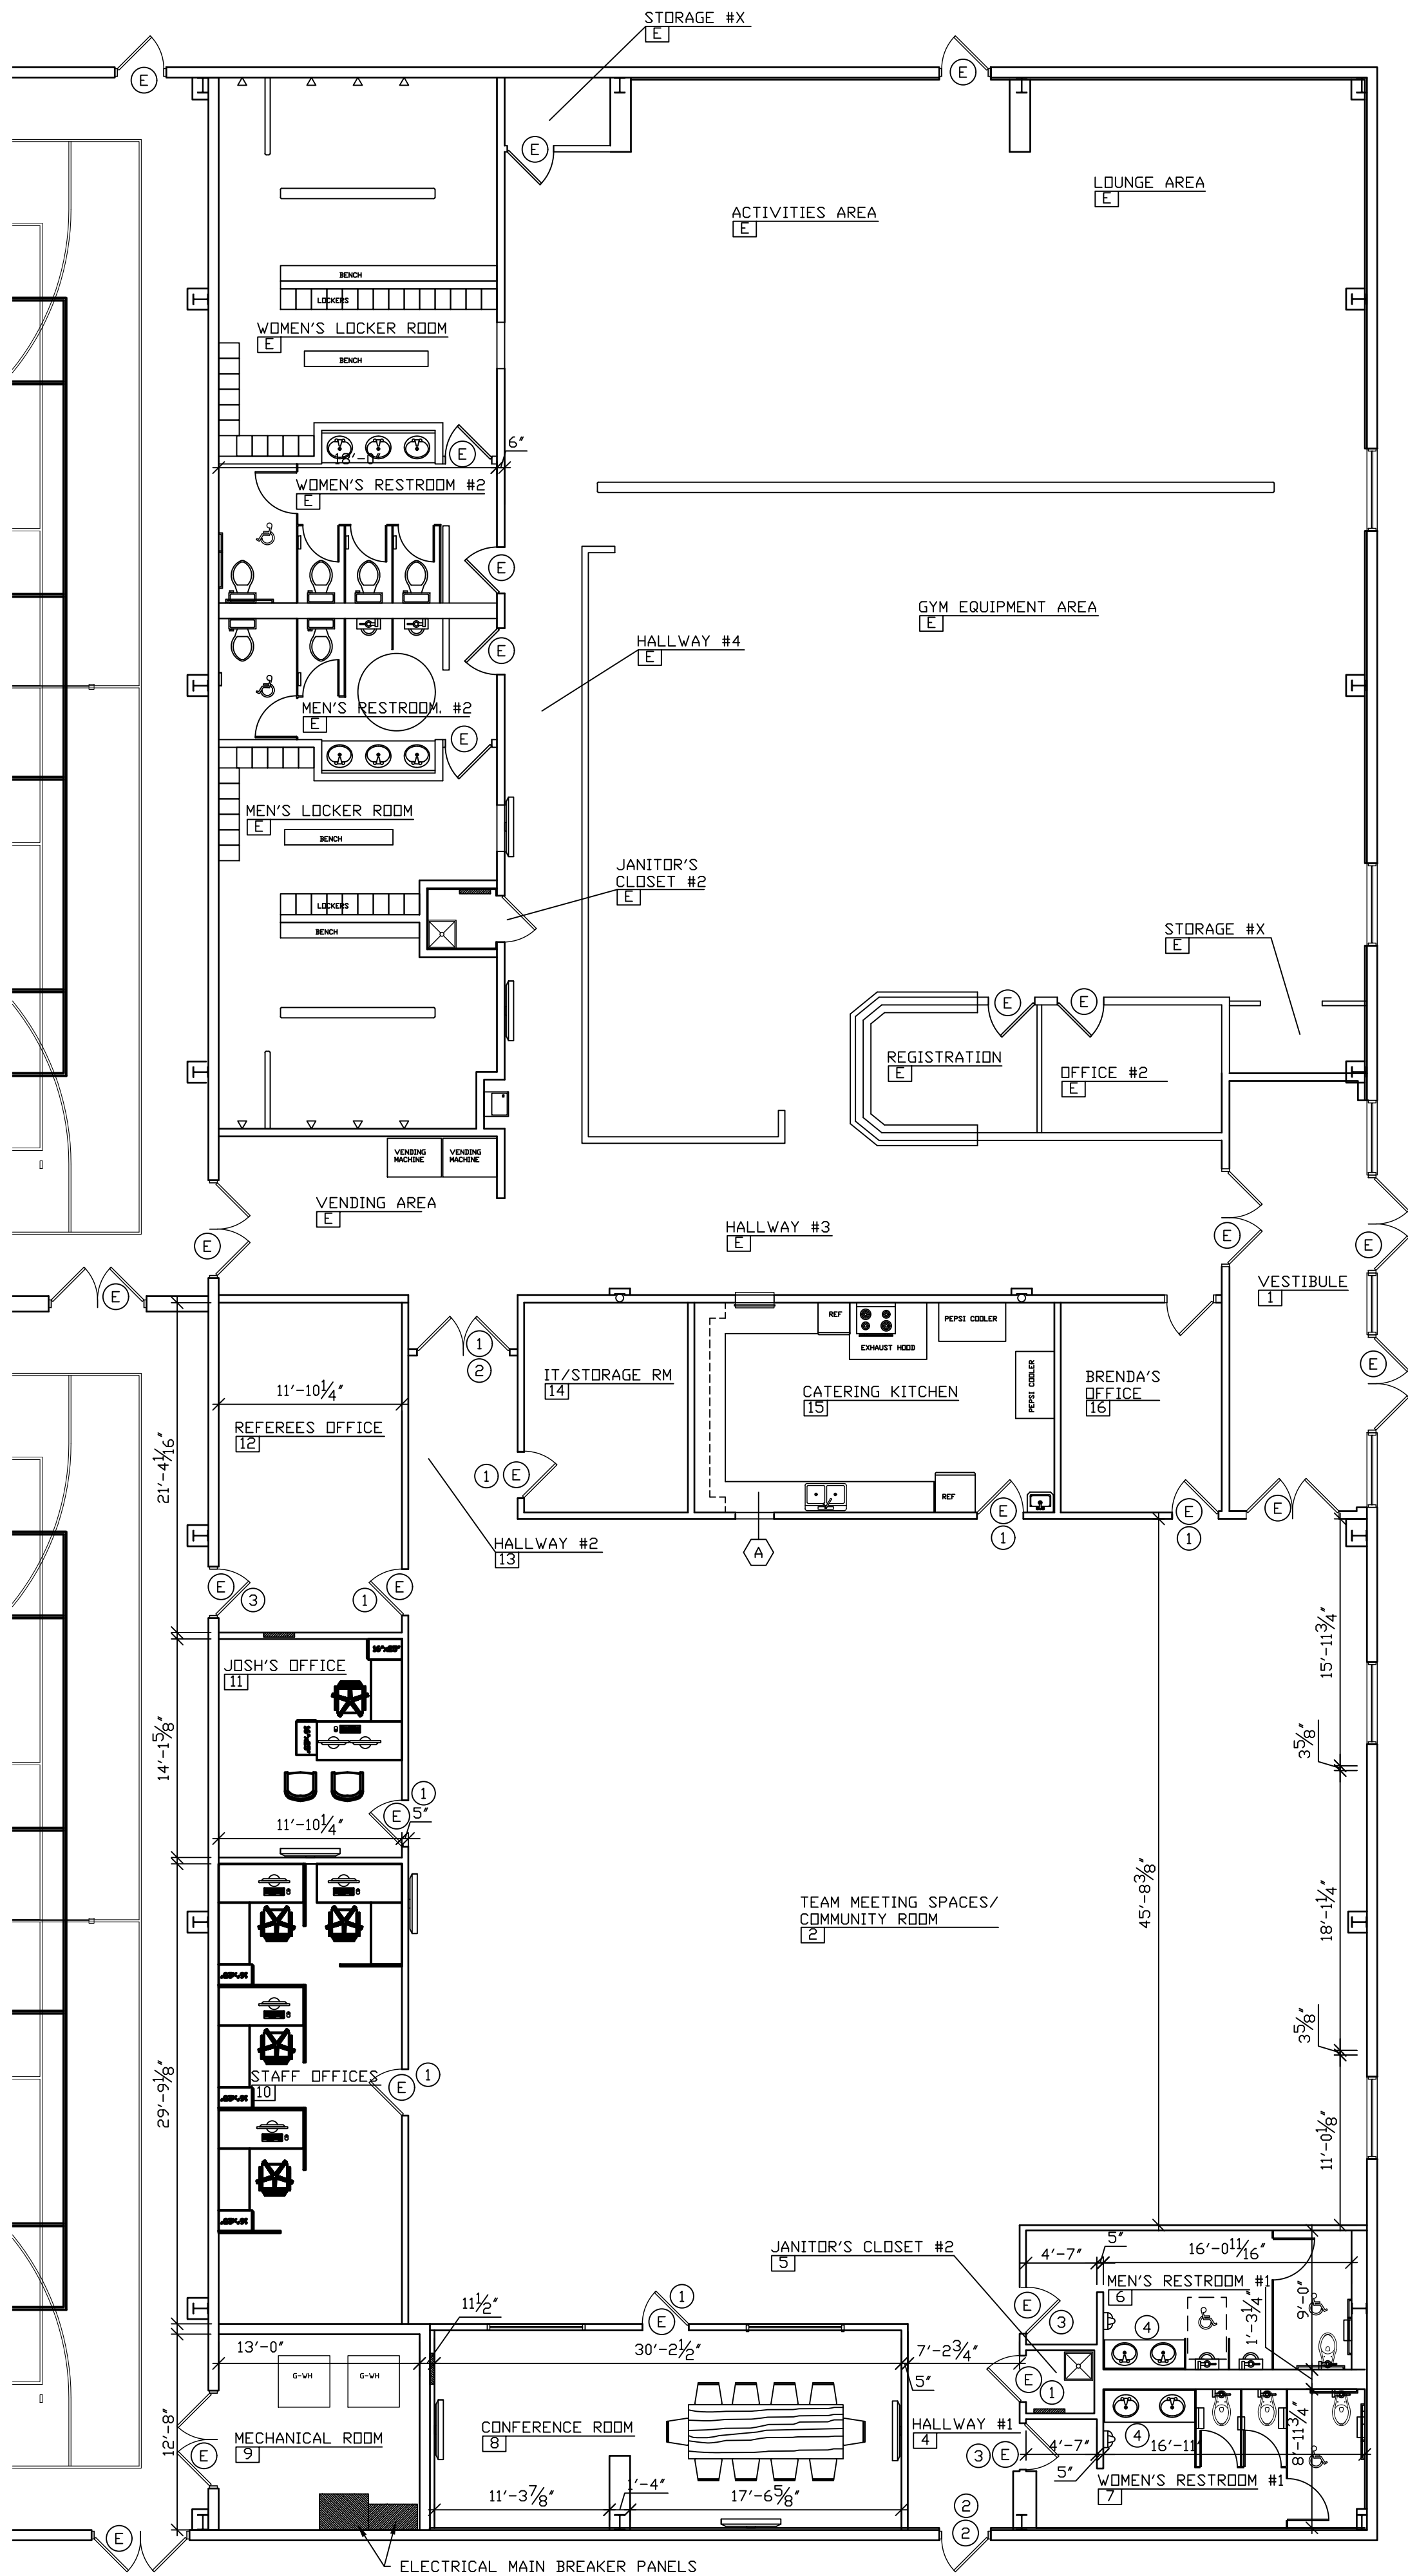


NUMBERED NOTES:

1. PAINT EXISTING HM STEEL FRAME. PRE-FINISHED SOLID WOOD DOOR TO REMAIN. CLEAN DOOR SLAB.
2. REMOVE EXISTING DOOR HARDWARE COMPLETE. PAINT EXISTING HM STEEL DOOR AND FRAME. INSTALL NEW HARDWARE.
3. REMOVE EXISTING HARDWARE COMPLETE. PAINT EXISTING HM STEEL DOOR AND FRAME. RE-INSTALL EXISTING HARDWARE.
4. NEW WALL SUPPORTED SOLID SURFACE COUNTERTOP WITH SIDE SPLASHES. COORDINATE LENGTH AS REQUIRED.

GENERAL NOTES:

1. REPAIR ALL WALLS AFTER REMOVAL OF VINYL WALL BASE AS REQUIRED.
2. REPAIR ALL WALLS AFTER REMOVAL OF CEILING GRID AS REQUIRED.
3. REPAIR ALL WALLS AS REQUIRED FROM OLD HOLES AND PICTURES.
4. PREPARE ALL HM STEEL FRAMES AND HM STEEL DOOR AS REQUIRED FOR PAINTING.

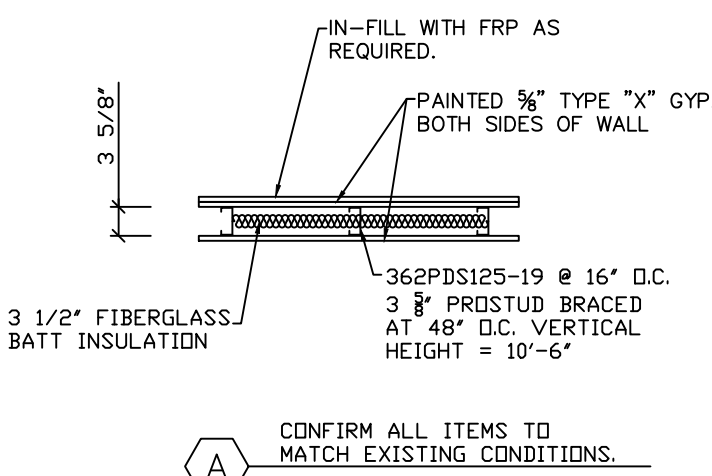

INTERIOR FINISH SCHEDULE

ROOM NUMBER	ROOM NAME	FLOOR	BASE	WALLS	CEILING	CLG/HT	REMARKS
		NEW EPOXY COATED CONCRETE	NEW LUXURY VINYL PLANK	NEW 4" VINYL	PAINTED GYP BOARD	EPOXY PAINTED GYPSUM BOARD	
01	VESTIBULE						
02	TEAM MTG/COMM ROOM						
03	NOT USED ON THIS PROJECT						NO WORK
04	HALLWAY #1						
05	JANITOR'S CLOSET #1						
06	MEN'S RESTROOM #1						
07	WOMEN'S RESTROOM #1						
08	CONFERENCE ROOM						
09	MECHANICAL ROOM						NO WORK
10	STAFF OFFICES						
11	JOSH'S OFFICE						
12	REFEREES OFFICE						
13	HALLWAY #2						
14	IT/STORAGE ROOM						
15	CATERING KITCHEN						
16	BRENDA'S OFFICE						

DOOR SCHEDULE

NO.	SIZE	DOOR			FRAME		REMARKS	NO.
		MATERIAL	GLAZING	ELEV.	JAMB	ELEV.		
1	(2)3'-0"x7'-0"x1 3/4"	HM STEEL	NONE	-	HM	-	HARDWARE SET #1	1
2	3'-0"x7'-0"x1 3/4"	HM STEEL	NONE	-	HM	-	HARDWARE SET #2	1

HARDWARE SET #1

1. EXISTING HM STEEL FRAME AND DOORS REMAIN.
2. EXISTING HINGES REMAIN.
3. REMOVE EXISTING SURFACE MOUNTED PANIC EXIT DEVICES WITH SURFACE MOUNTED RODS.
4. INSTALL NEW SURFACE MOUNTED PANIC EXIT DEVICES WITH SURFACE MOUNTED RODS - TOP AND BOTTOM. MATCH EXISTING. MATCH EXISTING KEYING AS REQUIRED.

HARDWARE SET #2

1. EXISTING HM STEEL FRAME AND DOORS REMAIN.
2. EXISTING HINGES REMAIN.
3. REMOVE EXISTING WEATHER STRIPPING COMPLETE. INSTALL NEW WEATHER STRIPPING AND BOTTOM SWEEP.
4. EXISTING LOCK AND CLOSURE REMAIN.

GENERAL HARDWARE NOTES

1. ALL HM STEEL DOORS, HM STEEL FRAMES, AND HARDWARE SHALL BE PURCHASED FROM CROSSROADS DOOR AND HARDWARE 1301 EAGLE STREET TERRE HAUTE, INDIANA 47807 PHONE: (812) 238-2692 NO SUBSTITUTIONS OR EXCEPTIONS.

GENERAL NOTES:

1. ALL FLOOR PLAN DIMENSIONS ARE FROM FACE OF STUD TO FACE OF STUD UNLESS NOTED OTHERWISE.
2. ALL INTERIOR STUDS SHALL BE 3 5/8" IN DEPTH UNLESS NOTED OTHERWISE.

THE CONTENTS OF THIS DOCUMENT ARE THE SOLE PROPERTY OF MICHAEL R. WALDBIESER ENGINEERING & CONSULTING, INC. AND MAY NOT BE REPRODUCED OR TRANSFERRED IN ANY WAY WITHOUT THE WRITTEN CONSENT OF MICHAEL R. WALDBIESER ENGINEERING & CONSULTING, INC. ALL REPORTS, PLANS, SPECIFICATIONS, COMPUTER FILES, FIELD DATA, NOTES, AND OTHER DOCUMENTS AND INSTRUMENTS PREPARED BY MICHAEL R. WALDBIESER ENGINEERING & CONSULTING, INC. (DESIGN PROFESSIONAL) AS INSTRUMENTS OF SERVICE SHALL REMAIN THE PROPERTY OF MICHAEL R. WALDBIESER ENGINEERING & CONSULTING, INC. MICHAEL R. WALDBIESER ENGINEERING & CONSULTING, INC. SHALL RETAIN ALL COMMON LAW, STATUTORY, AND OTHER RESERVED RIGHTS, INCLUDING THE COPYRIGHT THEREIN. THIS STATEMENT SHALL NOT BE REMOVED FROM THIS DRAWING FOR ANY REASON.

DATE	REVISIONS	BY



BIRD GIBSON SPORTS CENTER
599 SOUTH TABORTOWN ROAD
TERRE HAUTE, INDIANA 47803
2025 BUILDING REMODEL PHASE 1

MICHAEL R. WALDBIESER
ENGINEER & CONSULTING, INC.
STRUCTURAL REMODELING, RENOVATION & ELECTRICAL DESIGN



PHONE: (812) 232-6510

SYCAMORE BUILDING
19 SOUTH 66th STREET, SUITE 804
TERRE HAUTE, INDIANA 47807

SCALE: 1/8" = 1'-0"
DATE: 07-13-26
DRAWN BY: WCF
APPROVED BY: MRW

PROJECT: 25-24
FILE: Model #F

1.2

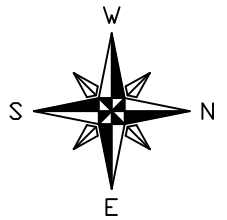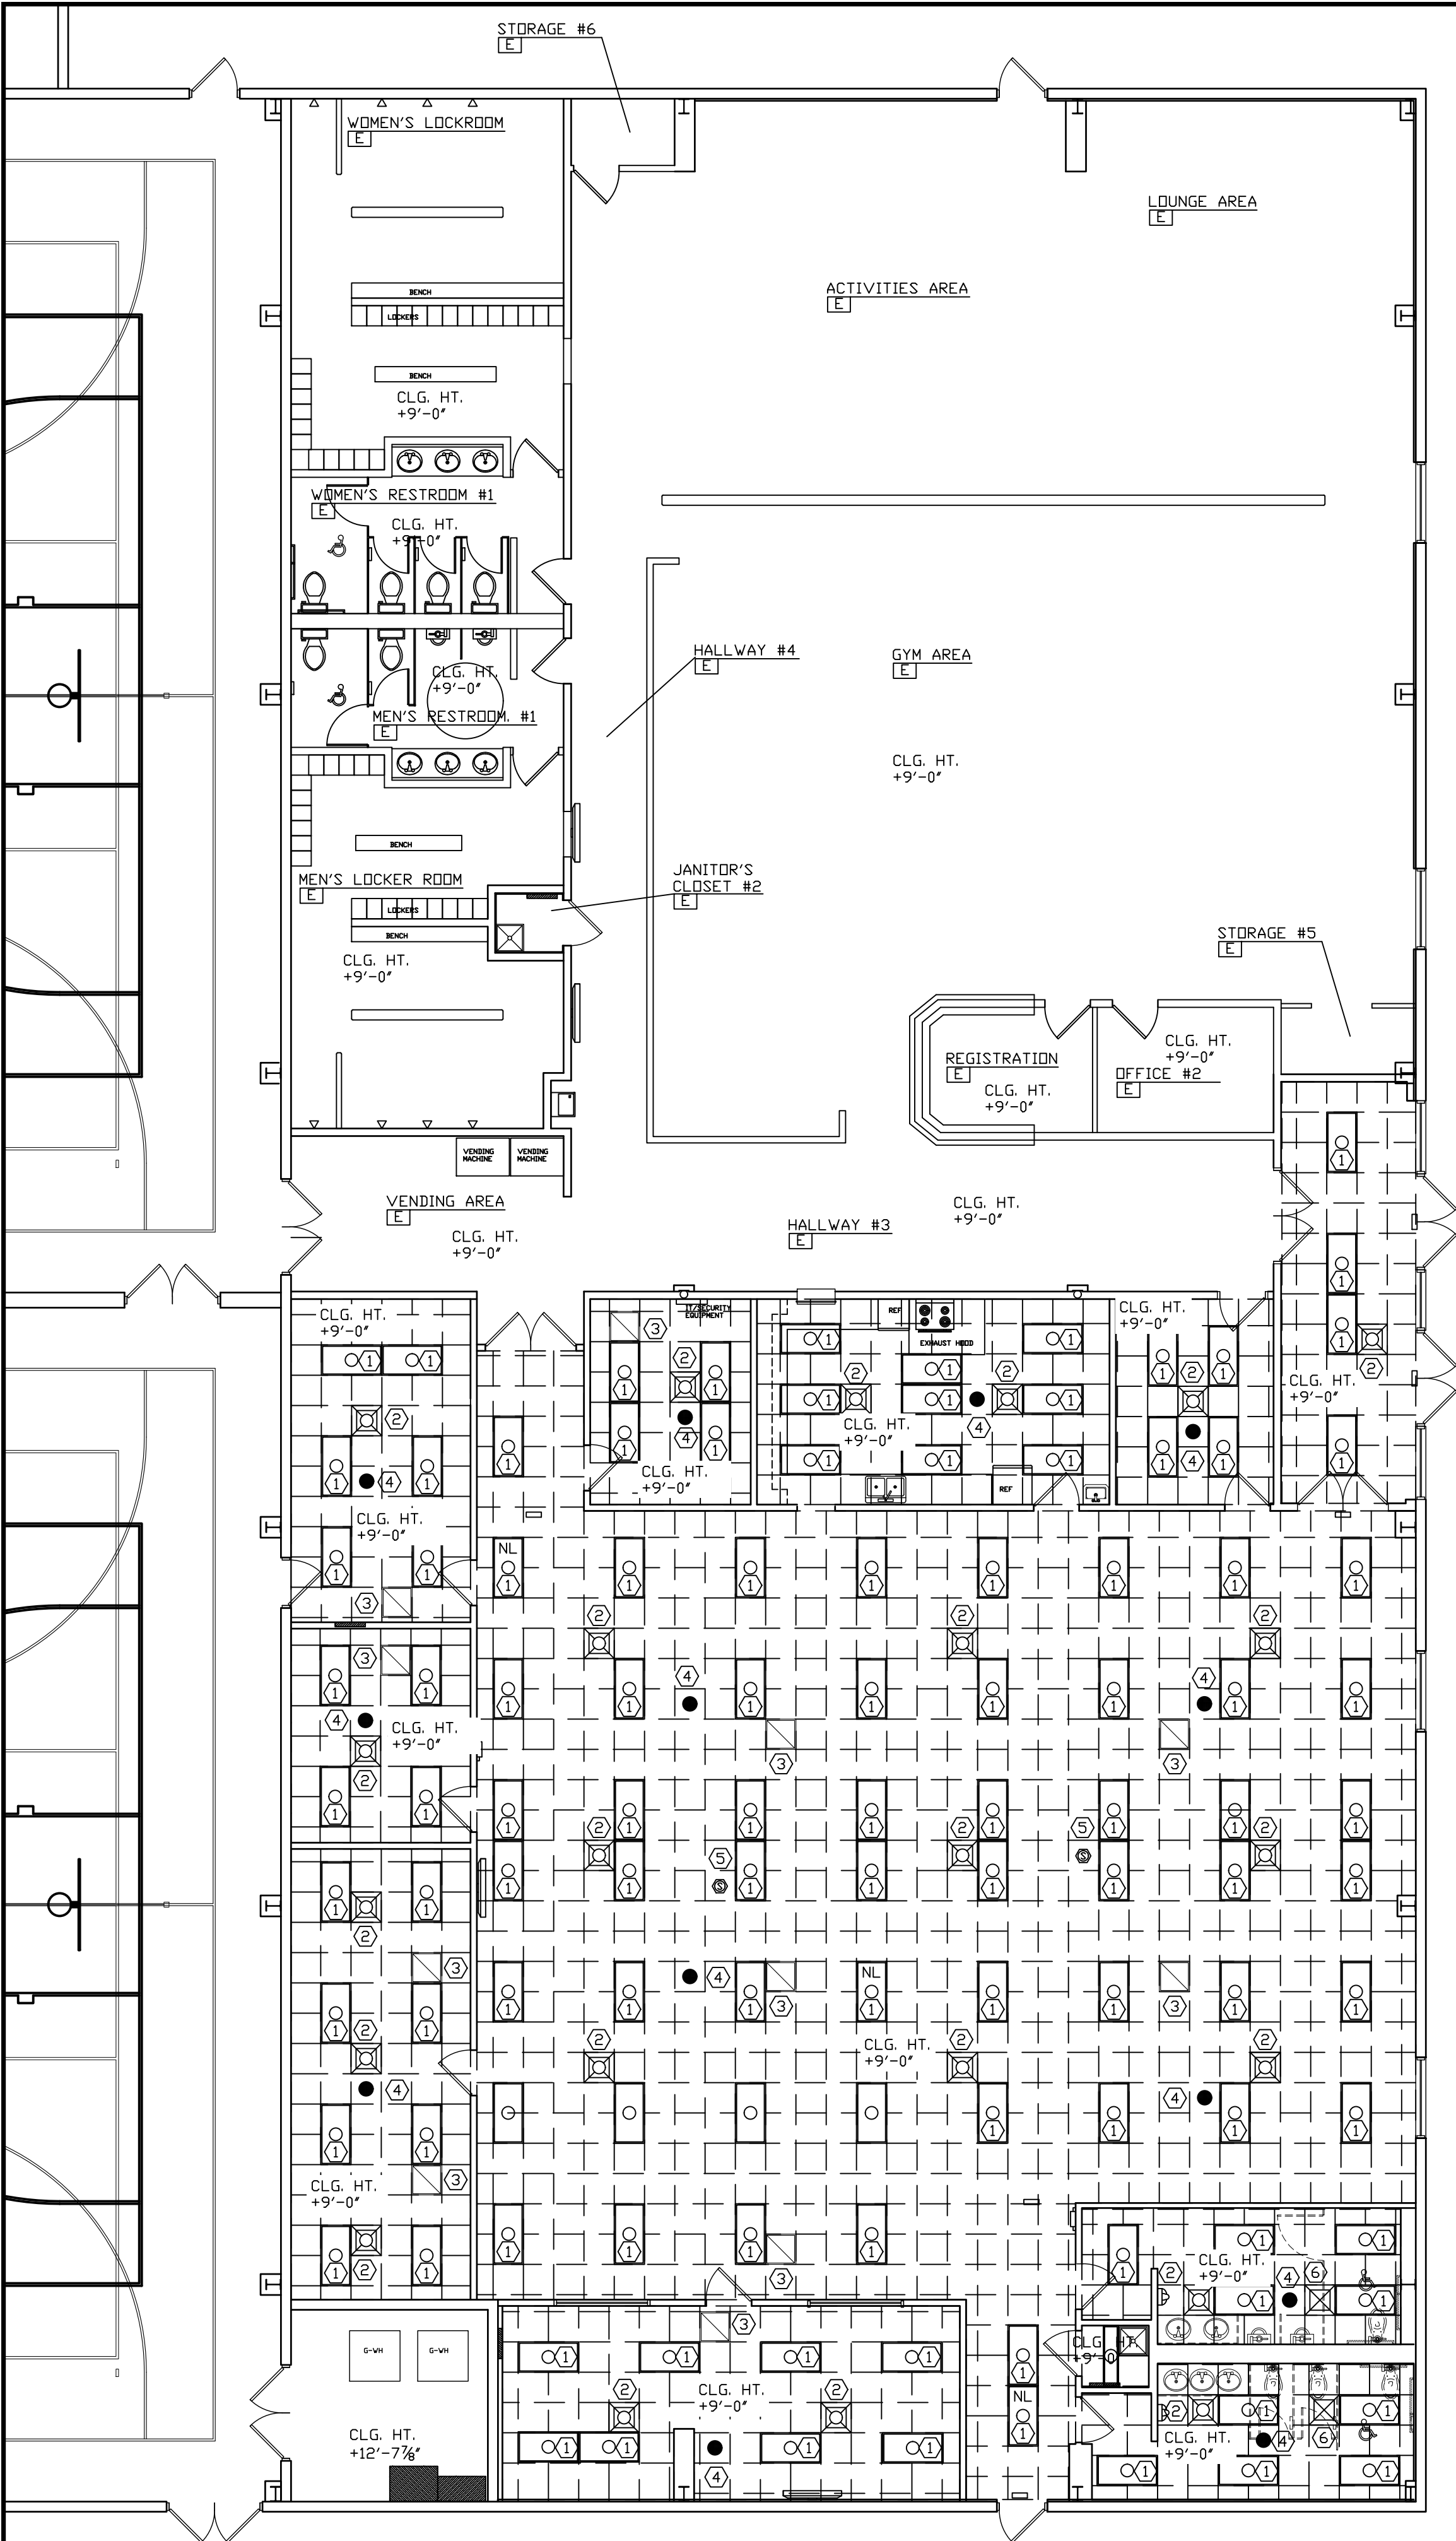


EXISTING/DEMOLITION
REFLECTIVE CEILING PLAN
SCALE: 1/8" = 1'-0"

NUMBERED NOTES:

- 1 REMOVE EXISTING LIGHT FIXTURE COMPLETE. WILL BE REPLACED WITH NEW LIGHT FIXTURE IN NEW CEILING GRID LAYOUT.
- 2 REMOVE EXISTING HVAC SUPPLY AIR GRILLE COMPLETE. WILL BE REPLACED AND RELOCATED TO NEW LOCATION.
- 3 REMOVE EXISTING HVAC RETURN AIR GRILLE COMPLETE. WILL BE REPLACED AND RELOCATED TO NEW LOCATION.
- 4 REMOVE EXISTING SPEAKER. CLEAN UNIT. WILL BE RE-INSTALLED IN NEW CEILING AT NEW LOCATION.
- 5 REMOVE EXISTING FIRE ALARM DEVICE. WILL BE RE-INSTALLED IN NEW CEILING AT NEW LOCATION.
- 6 REMOVE EXISTING EXHAUST FAN GRILLE COMPLETE. WILL BE REPLACED AND RELOCATED TO NEW LOCATION.

DATE	REVISIONS	BY

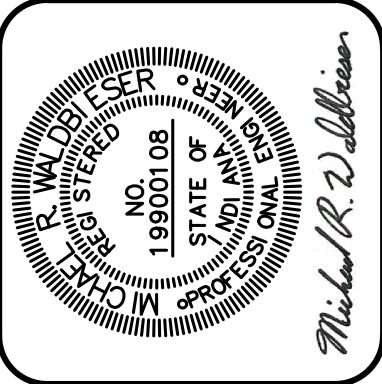

BIRD GIBSON SPORTS CENTER
599 SOUTH TABORTOWN ROAD
TERRE HAUTE, INDIANA 47803

2026 BUILDING REMODEL PHASE 1

MICHAEL R. WALDBIESER
ENGINEER & CONSULTING, INC.
STRUCTURAL, MECHANICAL, ELECTRICAL, PLUMBING

PHONE: (812) 232-6510

SYCAMORE BUILDING
19 SOUTH 66th STREET, SUITE 804
TERRE HAUTE, INDIANA 47807

SCALE: 1/8" = 1'-0"

DATE: 07-13-26


DRAWN BY: WCF

APPROVED BY: MRW

PROJECT: 25-24
FILE: Model #F

2.0

THE CONTENTS OF THIS DOCUMENT ARE THE SOLE PROPERTY OF MICHAEL R. WALDBIESER ENGINEERING & CONSULTING, INC. AND MAY NOT BE REPRODUCED OR TRANSFERRED IN ANY WAY WITHOUT THE WRITTEN CONSENT OF MICHAEL R. WALDBIESER ENGINEERING & CONSULTING, INC.
ALL REPORTS, PLANS, SPECIFICATIONS, COMPUTER FILES, FIELD DATA, NOTES, AND OTHER DOCUMENTS AND INSTRUMENTS PREPARED BY MICHAEL R. WALDBIESER ENGINEERING & CONSULTING, INC. (DESIGN PROFESSIONAL) AS INSTRUMENTS OF SERVICE SHALL REMAIN THE PROPERTY OF MICHAEL R. WALDBIESER ENGINEERING & CONSULTING, INC. MICHAEL R. WALDBIESER ENGINEERING & CONSULTING, INC. SHALL RETAIN ALL COMMON LAW, STATUTORY, AND OTHER RESERVED RIGHTS, INCLUDING THE COPYRIGHT THEREON. THIS STATEMENT SHALL NOT BE REMOVED FROM THIS DRAWING FOR ANY REASON.

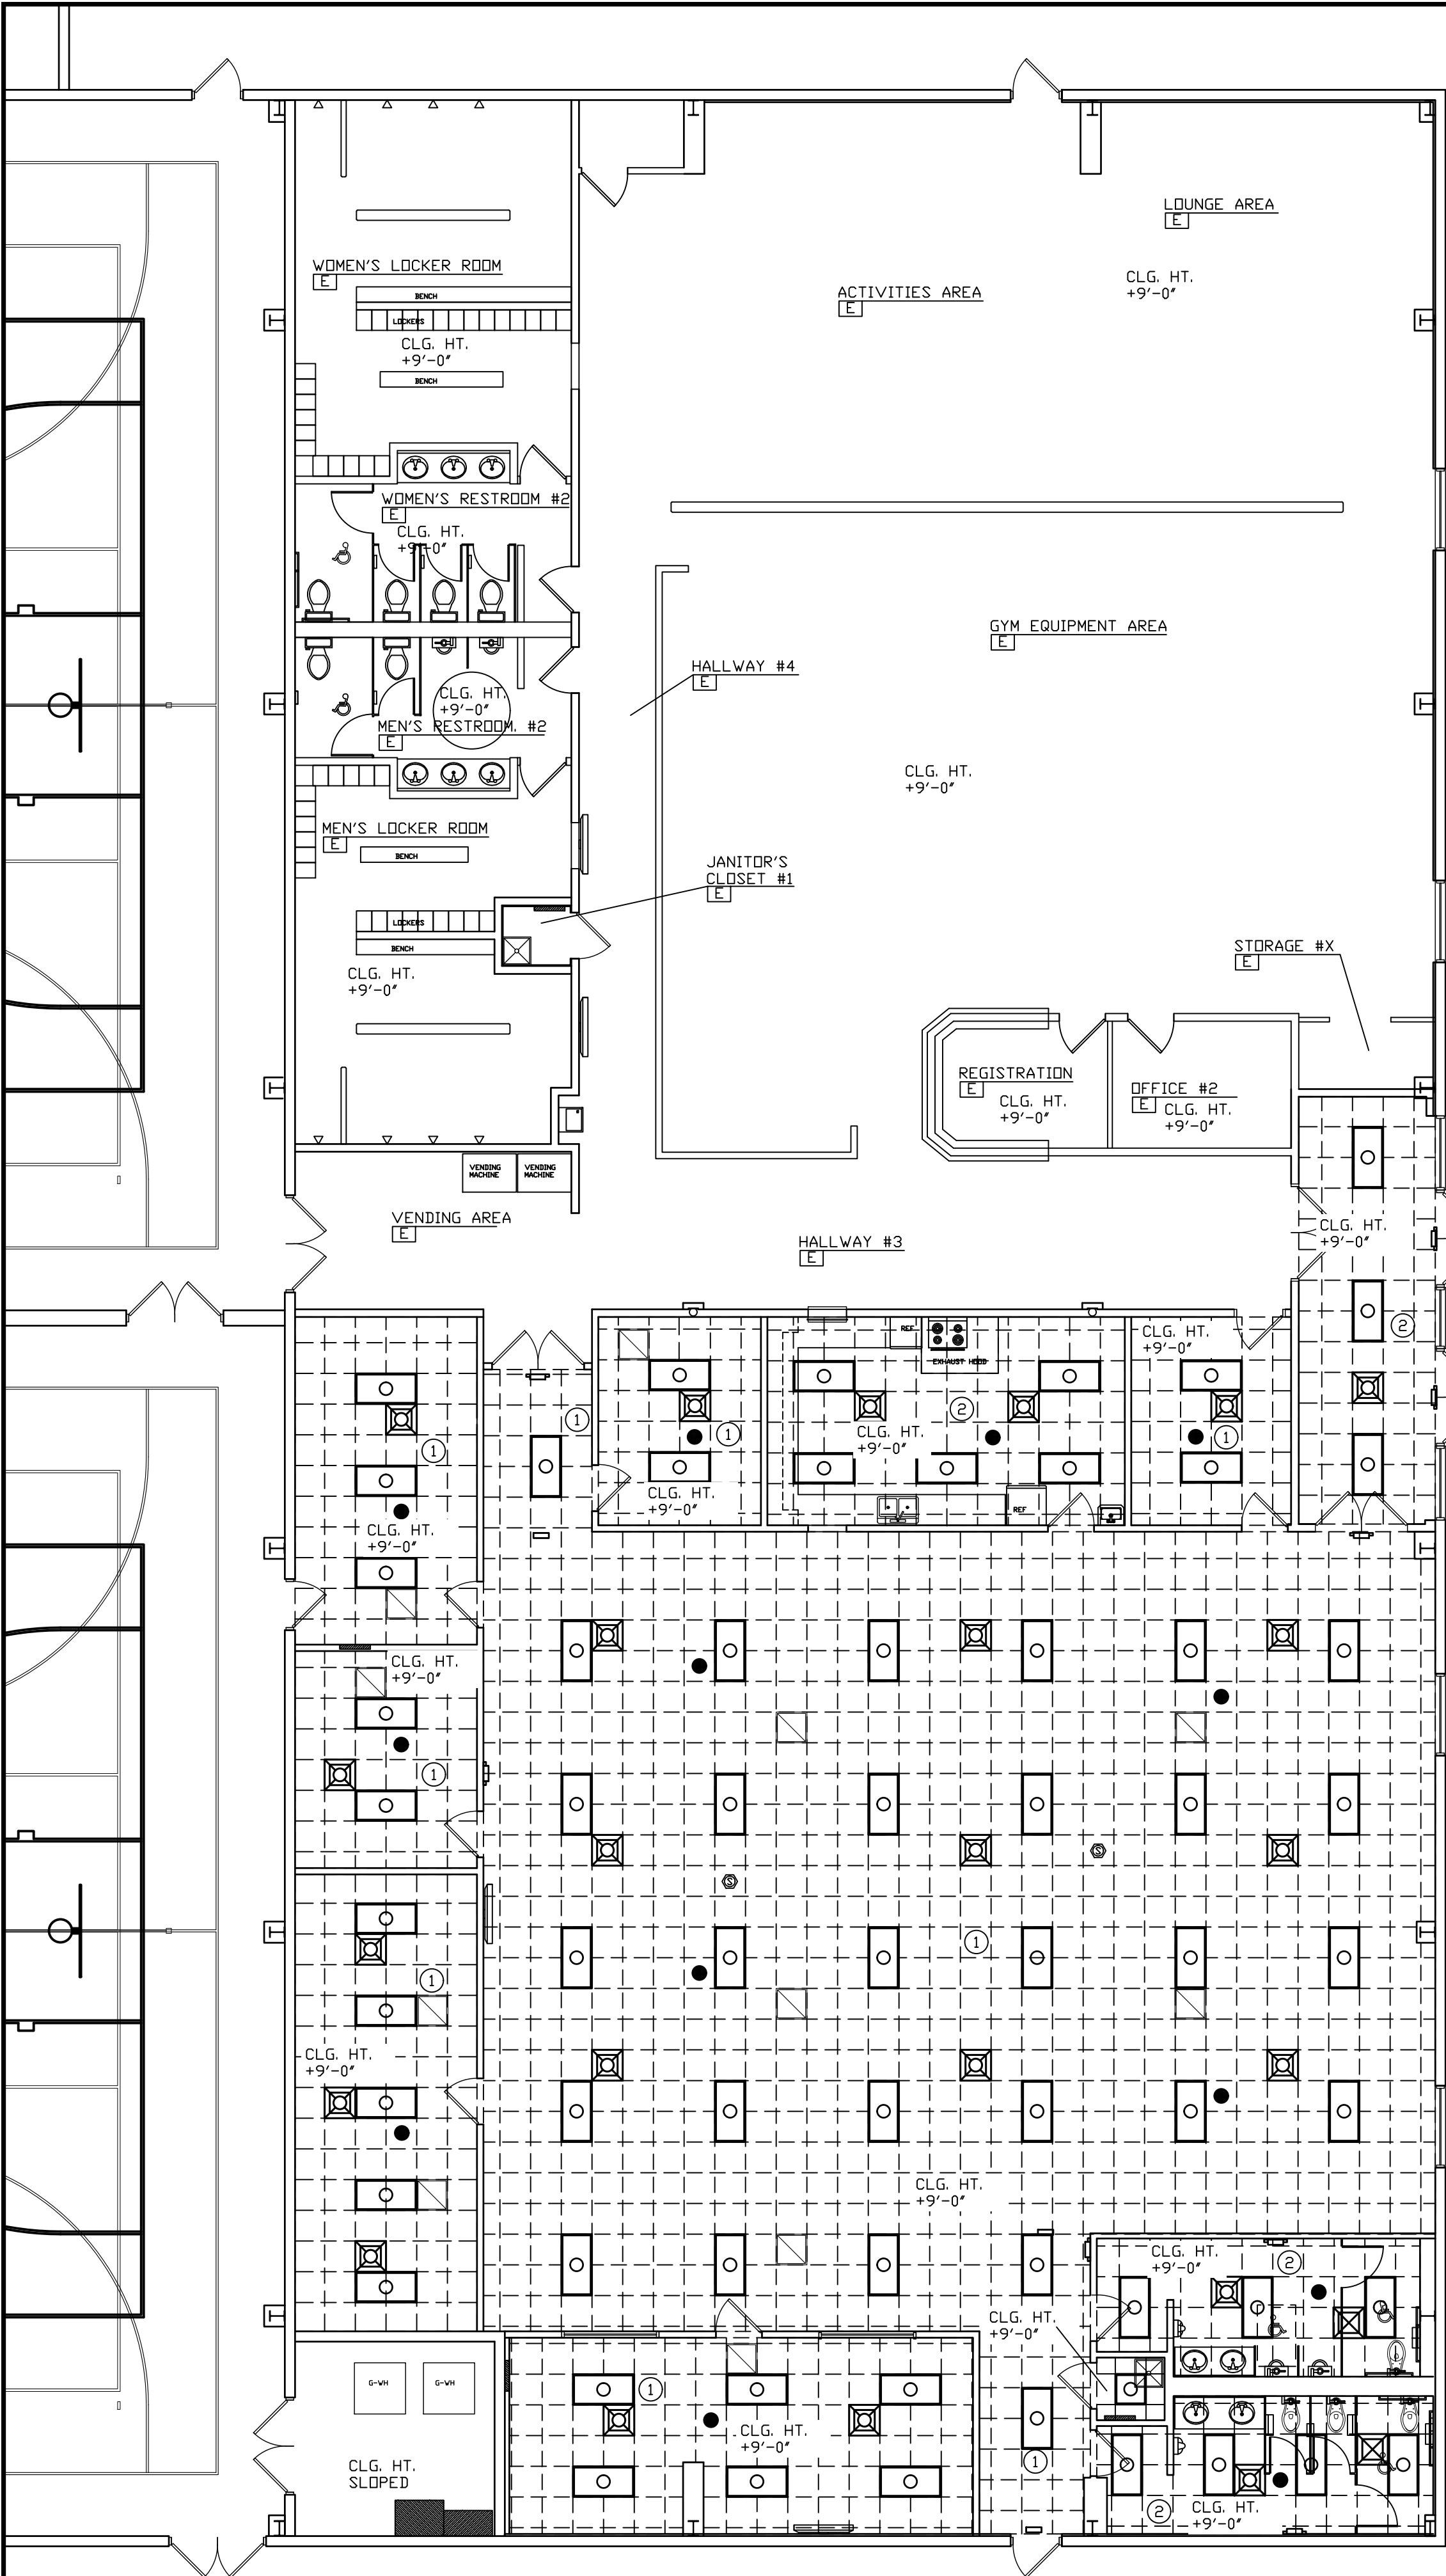

NEW REFLECTIVE CEILING PLAN
SCALE: 1/8" = 1'-0"

NUMBERED NOTES:

- ① INSTALL USG OLYMPIA MICRO ACOUSTICAL PANEL IN THIS ROOM.
EDGE: SQ
SIZE: 2'-0 X 2'-0
GRID: WHITE USG DX
- ② INSTALL USG RADAR CERAMIC ACOUSTICAL PANELS IN THIS ROOM.
EDGE: SQ
SIZE: 2'-0 X 2'-0
GRID: ALUMINUM WHITE USG AX

PAINT SPECIFICATIONS

1.0 EXTERIOR PAINT SCHEDULE

A. Painted Galvanized Hollow Metal Steel Door and Frame:

- Hand tool and solvent clean to remove any existing oils or failed primers.
- Application by brush or roller on remaining items.
- First Coat: Acrylic Primer
 - Sherwin Williams Galvite HS
- Second and Third Coats: Urethane Alkyd Enamel
 - Sherwin Williams Pro Industrial Urethane Alkyd Enamel

2.0 INTERIOR PAINT SCHEDULE

A. Painted Gypsum Drywall:

- Application by brush and roller.
- First Coat: Latex Primer
 - Sherwin Williams Premium Wall & Wood
- Second and Third Coats: Interior Latex
 - Sherwin Williams SuperPaint Interior Acrylic Latex

B. Painted Hollow Metal Steel Door and Frame:

- Application by brush and roller.
- First Coat: Pre-Primed by Mfg.
- Second and Third Coats: Urethane Alkyd Enamel
 - Sherwin Williams Pro Industrial Urethane Alkyd Enamel

C. Painted Gypsum Drywall:

Walls for Mens RR #1 and Womens RR #1:

- Application by brush and roller.
- First Coat: Latex Primer
 - Sherwin Williams ProMar 200 Interior Latex Primer
- Second and Third Coats: Pre-Catalyzed Waterbased Epoxy
 - Sherwin Williams Pro Industrial Pre-Catalyzed Waterbased Epoxy

- Notes:
- Apply primer as required to cover existing color/surface for proper adhesive and coverage.
 - Sheen to be selected by Owner for all paints.

LUXURY VINYL PLANK SPECIFICATIONS

- Use an allowance of \$5.00/sf for luxury vinyl plank flooring and adhesive.
- Does not include labor to install new flooring.
- Does not include labor to remove existing flooring.
- Does not include labor/supplies to prepare existing floor for new luxury vinyl plank flooring.

EPOXY FLOOR COATING SPECIFICATIONS

- Use an allowance of \$3.50/sf for epoxy floor coating.
- Does not include labor to install new epoxy floor coating.
- Does not include labor/supplies to prepare existing floor for new epoxy floor coating. Existing epoxy flooring will need to be removed by grinding.

DATE	REVISIONS	BY



BIRD GIBSON SPORTS CENTER
599 SOUTH TABORTOWN ROAD
TERRE HAUTE, INDIANA 47803

2026 BUILDING REMODEL PHASE 1

MICHAEL R. WALDBIESER
ENGINEER & CONSULTING, INC.
STRUCTURAL, REMEDIATION, MECHANICAL & ELECTRICAL DESIGN

SYCAMORE BUILDING
19 SOUTH 66th STREET, SUITE 804
TERRE HAUTE, INDIANA 47807

PHONE: (812) 232-6510

SCALE: 1/8" = 1'-0"

DATE: 07-13-26


DRAWN BY: WCF

APPROVED BY: MRW

PROJECT: 25-24
FILE: Model #F


2.1

THE CONTENTS OF THIS DOCUMENT ARE THE SOLE PROPERTY OF MICHAEL R. WALDBIESER ENGINEERING & CONSULTING, INC. AND MAY NOT BE REPRODUCED OR TRANSFERRED IN ANY WAY WITHOUT THE WRITTEN CONSENT OF MICHAEL R. WALDBIESER ENGINEERING & CONSULTING, INC.
ALL REPORTS, PLANS, SPECIFICATIONS, COMPUTER FILES, FIELD DATA, NOTES, AND OTHER DOCUMENTS AND INSTRUMENTS PREPARED BY MICHAEL R. WALDBIESER ENGINEERING & CONSULTING, INC. (DESIGN PROFESSIONAL) AS INSTRUMENTS OF SERVICE SHALL REMAIN THE PROPERTY OF MICHAEL R. WALDBIESER ENGINEERING & CONSULTING, INC. MICHAEL R. WALDBIESER ENGINEERING & CONSULTING, INC. SHALL RETAIN ALL COMMON LAW, STATUTORY, AND OTHER RESERVED RIGHTS, INCLUDING THE COPYRIGHT THEREON. THIS STATEMENT SHALL NOT BE REMOVED FROM THIS DRAWING FOR ANY REASON.

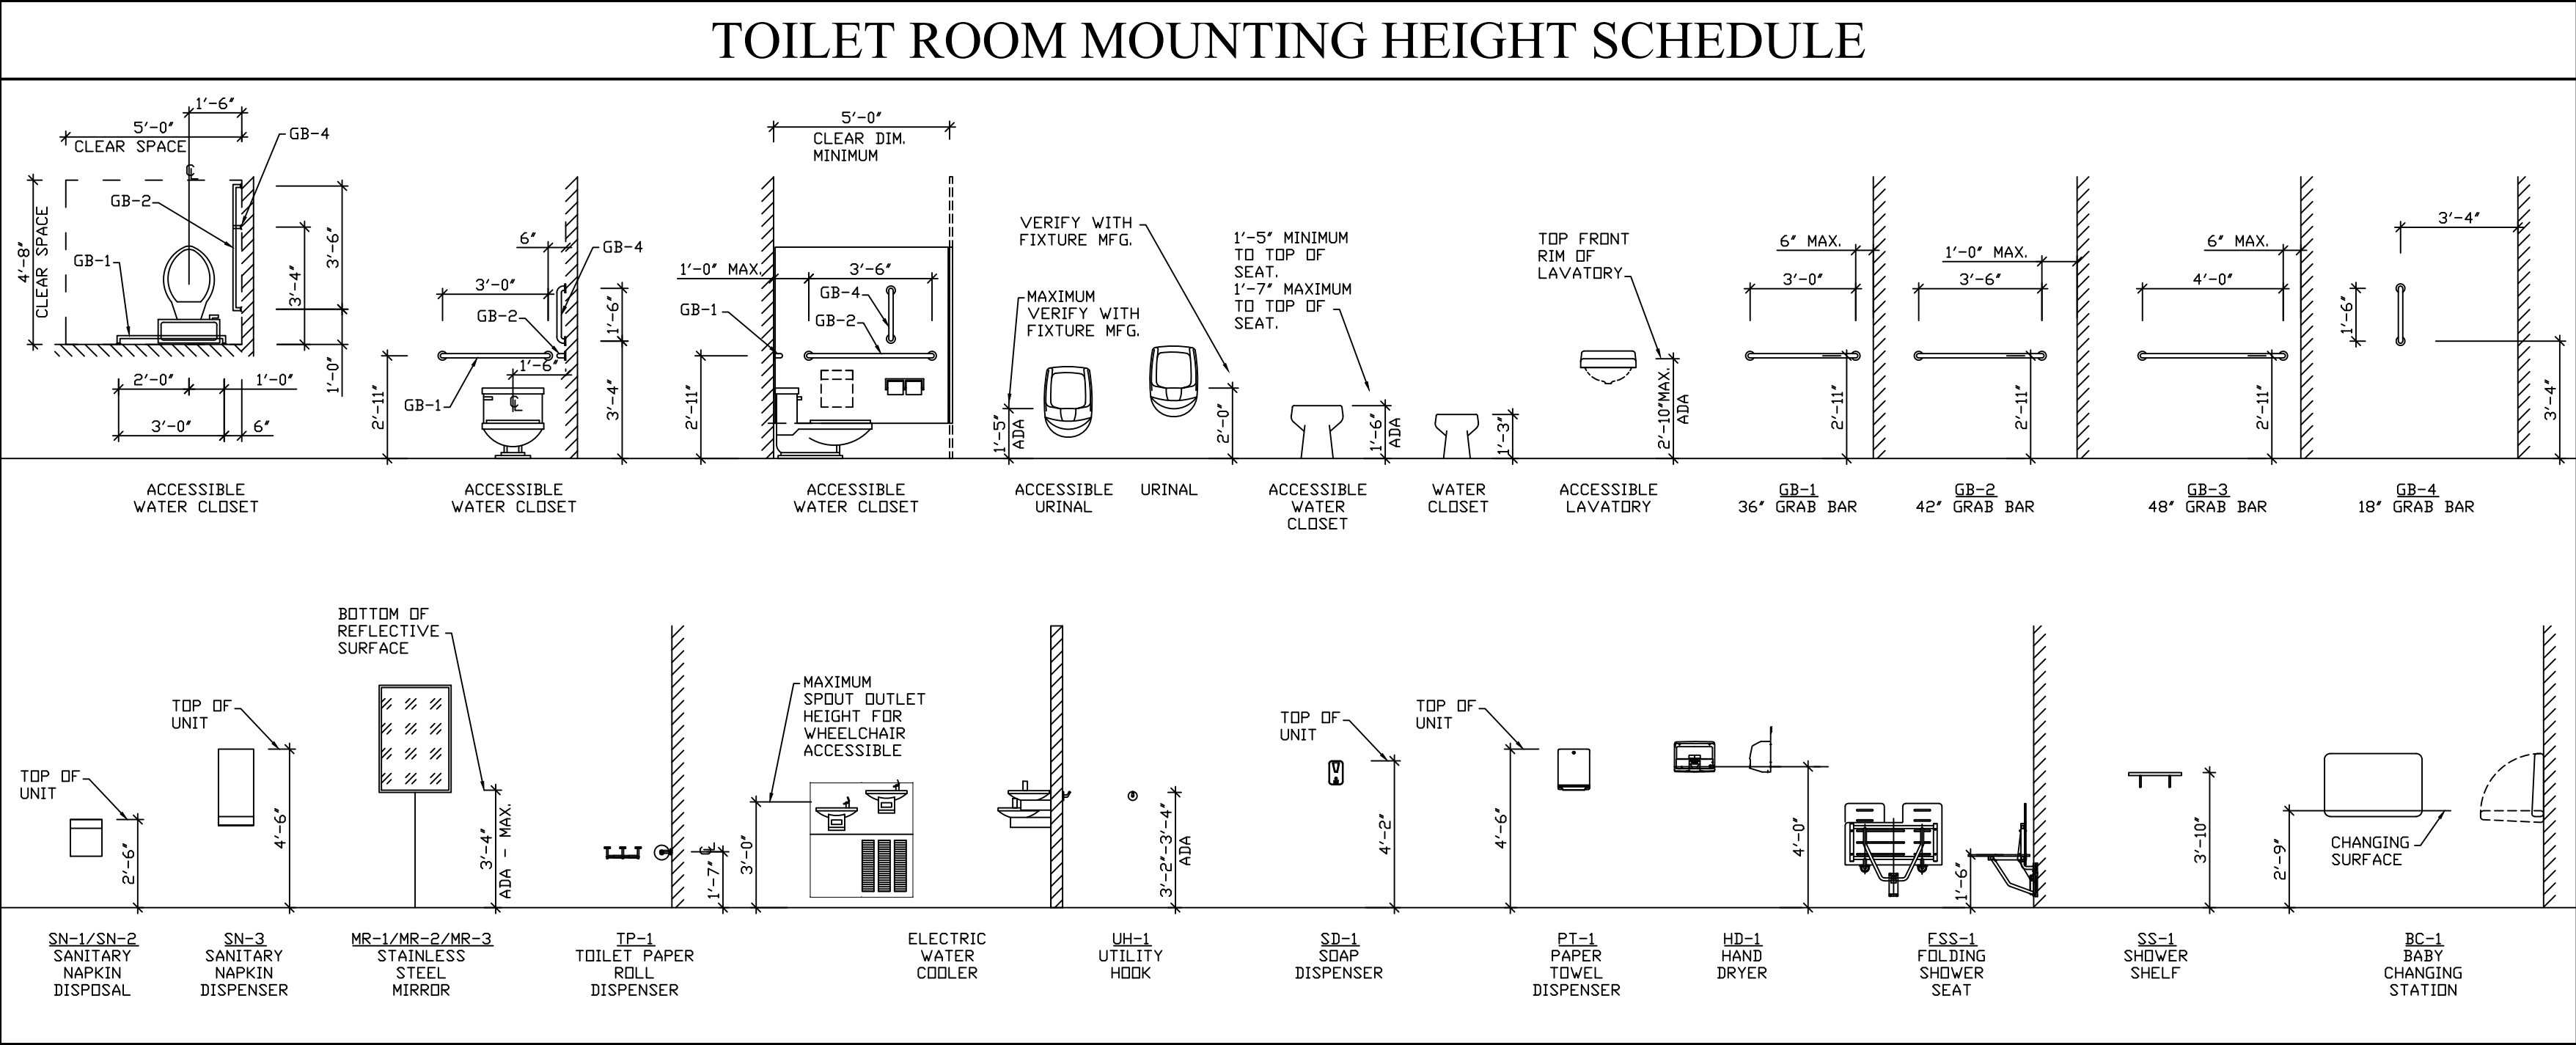

TOILET ROOM ACCESSORY SCHEDULE					
SYMBOL	DESCRIPTION	MANUFACTURER	MODEL	FINISH	REMARKS
BC-1	BABY CHANGING STATION	KDALA KARE	KB200	COLOR BY OWNER	MOUNTING PER MFG.
FSS-1	FOLDING SHOWER SEAT	BOBRICK	B-5181	STAINLESS - SOLID PHENOLIC TOP	MOUNTING PER MFG.
GB-1	36" GRAB BAR	BOBRICK	B-6806	SS-304 SATIN	1 1/2" DIA. WITH SNAP FLANGES
GB-2	42" GRAB BAR	BOBRICK	B-6806	SS-304 SATIN	1 1/2" DIA. WITH SNAP FLANGES
GB-3	48" GRAB BAR	BOBRICK	B-6806	SS-304 SATIN	1 1/2" DIA. WITH SNAP FLANGES
GB-4	18" VERTICAL GRAB BAR	BOBRICK	B-6806	SS-304 SATIN	1 1/2" DIA. WITH SNAP FLANGES
HD-1	HAND DRYER	BOBRICK	B-700	WHITE	115 VOLT, 2300 WATTS, 20 AMP
UH-1	UTILITY HOOK	BOBRICK	B-6707	SS-304 SATIN	-
MR-1	MIRROR (18" WIDE BY 30" HIGH)	BOBRICK	B-290	SS-304 SATIN	-
MR-2	MIRROR (18" WIDE BY 30" HIGH)	BOBRICK	B-292	SS-304 SATIN	UNIT HAS 5" SHELF
MR-3	MIRROR (18" WIDE BY 30" HIGH)	BOBRICK	B-293	SS-304 SATIN	HC TILT MIRROR
SCR-1	SHOWER CURTAIN ROD	BOBRICK	B-6047	SS-304 SATIN	1 1/4" 18-GAUGE - LENGTH AS REQUIRED
SCR-2	SHOWER CURTAIN ROD	BOBRICK	B-6107	SS-304 SATIN	1" 20-GAUGE - LENGTH AS REQUIRED
SD-1	SOAP DISPENSER, SURFACE MOUNTED	BOBRICK	B-2111	SS-304 SATIN	-
SD-2	SOAP DISPENSER, LAVATORY MOUNTED	BOBRICK	B-822	SS-304 SATIN	-
SN-1	SANITARY NAPKIN DISPOSAL	BOBRICK	B-353	SS-304 SATIN	RECESSED MOUNTED
SN-2	SANITARY NAPKIN DISPOSAL	BOBRICK	B-354	SS-304 SATIN	PARTITION MOUNTED
SN-3	SANITARY NAPKIN DISPOSAL	BOBRICK	B-254	SS-304 SATIN	SURFACE MOUNTED
SN-4	SANITARY NAPKIN DISPENSER - SURFACE	BOBRICK	B-2706	SS-304 SATIN	FREE OR COIN OPERATION PER OWNER
SS-1	SHOWER SHELF	BOBRICK	B-296x18	SS-304 SATIN	18" LONG SHELF
PT-1	PAPER TOWEL DISPENSER	BOBRICK	B-262	SS-304 SATIN	FOR USE WITH 400 C-FOLD PAPER TOWELS
PT-2	AUTOMATIC PAPER TOWEL DISPENSER				FIELD VERIFY AND MATCH EXISTING
TP-1	TOILET PAPER DISPENSER	BOBRICK	B-6867	SS-304 SATIN	DOUBLE ROLL DISPENSER
TP-2	TOILET PAPER DISPENSER	WAUSAU PAPER	88400	BLACK TRANSLUCENT	SILHOUETTE WAGON WHEEL - FOUR ROLL DISP. VERIFY WITH OWNER

- GENERAL NOTES:
- PROVIDE AND INSTALL WALL BLOCKING AS REQUIRED BY THE MFG. FOR ALL SPECIFIED ITEMS.
 - MOUNTING HEIGHTS ARE FOR SPECIFIED ITEMS. IF SUBSTITUTIONS ARE MADE, IT IS THE RESPONSIBILITY OF THE CONTRACTOR TO MOUNT THE ITEMS TO ADA/MFG. REQUIREMENTS.

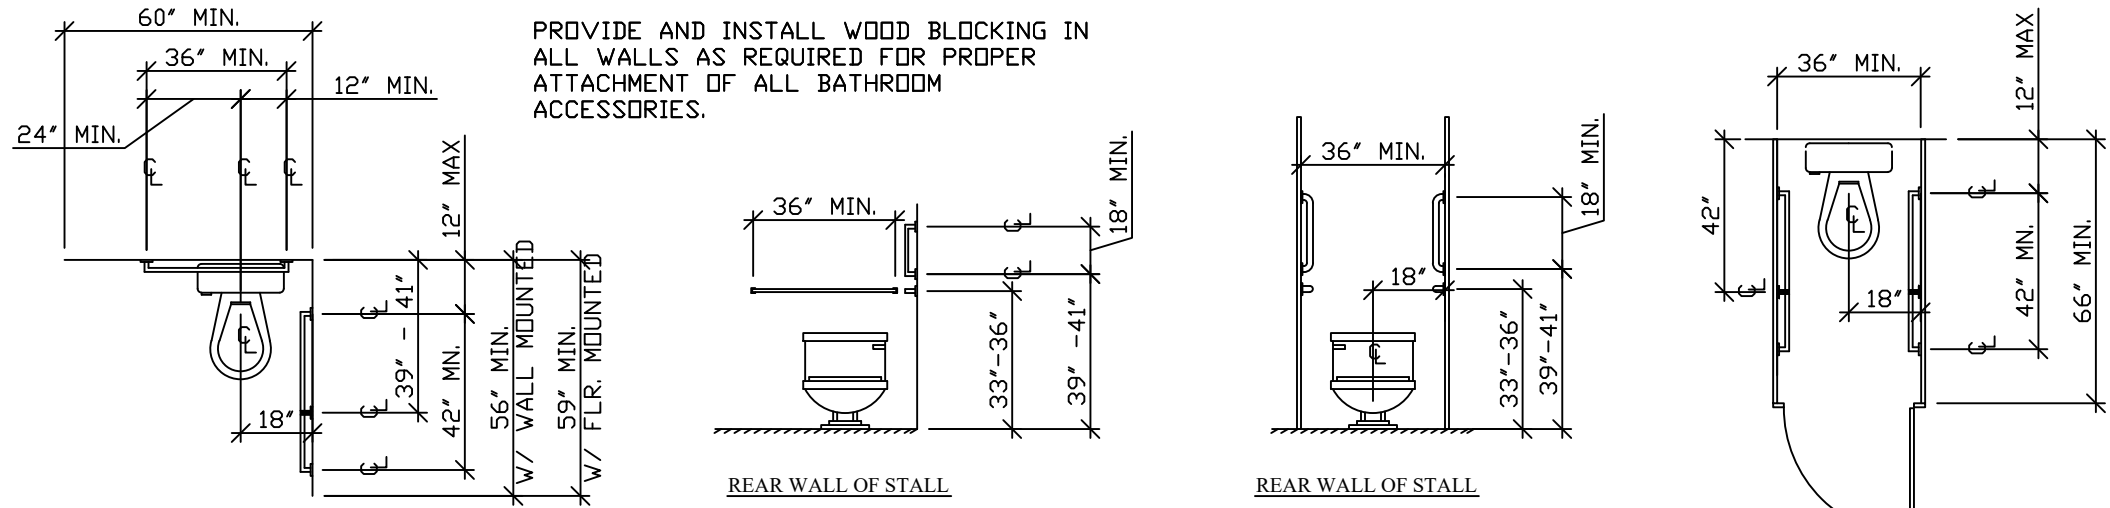


STANDARD HANDICAP STALL LAYOUT

AMBULATORY HANDICAP STALL LAYOUT

TOILET PARTITION SPECIFICATION:


- TOILET PARTITIONS SHALL BE BOBRICK 1090 SERIES SOLID COLOR REINFORCED COMPOSITE. FLOOR ANCHORED PARTITIONS.
- PROVIDE WITH CONTINUOUS HINGE OPTION.
- URINAL SCREENS SHALL BE WALL MOUNTED 24"x42".
- FIELD VERIFY ALL DIMENSIONS PRIOR TO SHOP DRAWING PREPARATION.

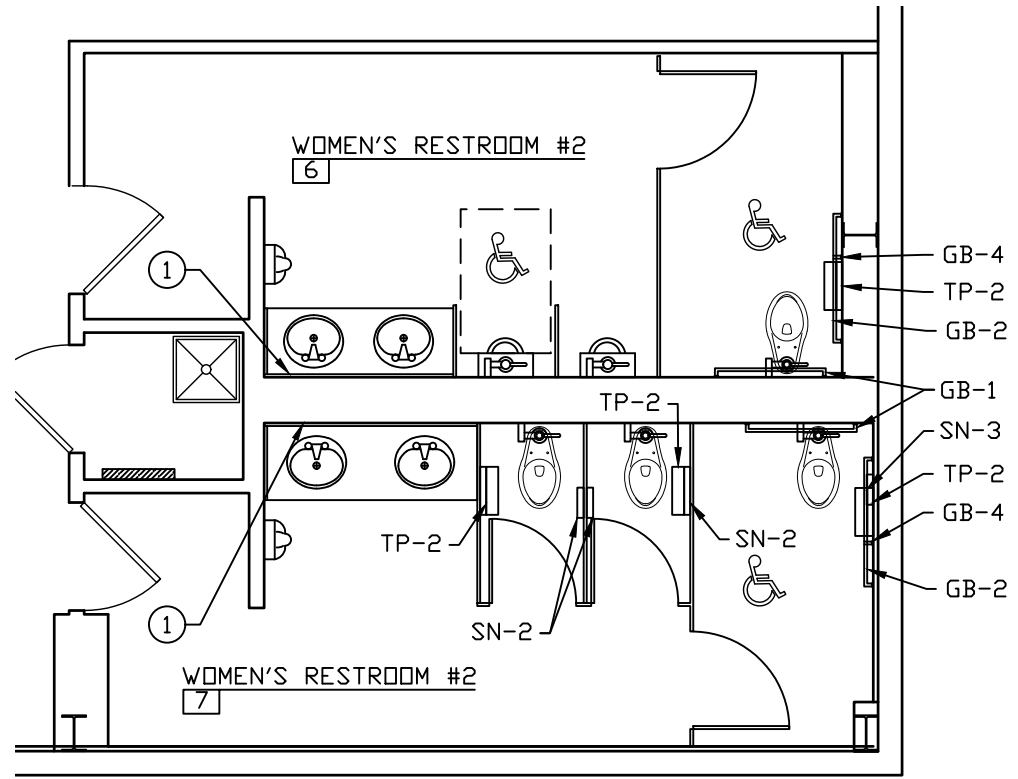

RESTROOM ACCESSORY PLAN

- NUMBERED NOTES:
- PROVIDE AND INSTALL A 30" HIGH BY LENGTH OF COUNTERTOP MIRROR WITH STAINLESS STEEL ANGLE FRAME.

DATE	REVISIONS	BY

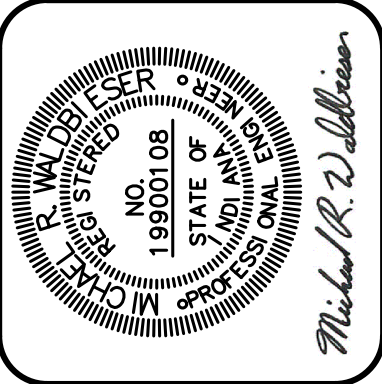

BIRD GIBSON SPORTS CENTER
599 SOUTH TABORTOWN ROAD
TERRE HAUTE, INDIANA 47803

2026 BUILDING REMODEL PHASE 1

MICHAEL R. WALDBIESER
ENGINEER & CONSULTING, INC.
STRUCTURAL, REMODELING, MECHANICAL & ELECTRICAL DESIGN

PHONE: (812) 232-6510

SYCAMORE BUILDING
19 SOUTH 66th STREET, SUITE 804
TERRE HAUTE, INDIANA 47807

SCALE: 3/16" = 1'-0"

DATE: 07-13-26



DRAWN BY: MRW

APPROVED BY: MRW

PROJECT: 25-24
FILE: Model #F

3.0



THE CONTENTS OF THIS DOCUMENT ARE THE SOLE PROPERTY OF MICHAEL R. WALDBIESER ENGINEERING & CONSULTING, INC. AND MAY NOT BE REPRODUCED OR TRANSFERRED IN ANY WAY WITHOUT THE WRITTEN CONSENT OF MICHAEL R. WALDBIESER ENGINEERING & CONSULTING, INC. ALL REPORTS, PLANS, SPECIFICATIONS, COMPUTER FILES, FIELD DATA, NOTES, AND OTHER DOCUMENTS AND INSTRUMENTS PREPARED BY MICHAEL R. WALDBIESER ENGINEERING & CONSULTING, INC. (DESIGN PROFESSIONAL) AS INSTRUMENTS OF SERVICE SHALL REMAIN THE PROPERTY OF MICHAEL R. WALDBIESER ENGINEERING & CONSULTING, INC. MICHAEL R. WALDBIESER ENGINEERING & CONSULTING, INC. SHALL RETAIN ALL COMMON LAW, STATUTORY, AND OTHER RESERVED RIGHTS, INCLUDING THE COPYRIGHT THERE TO. THIS STATEMENT SHALL NOT BE REMOVED FROM THIS DRAWING FOR ANY REASON.

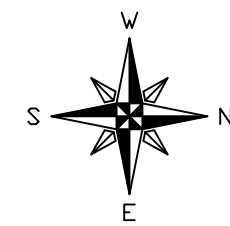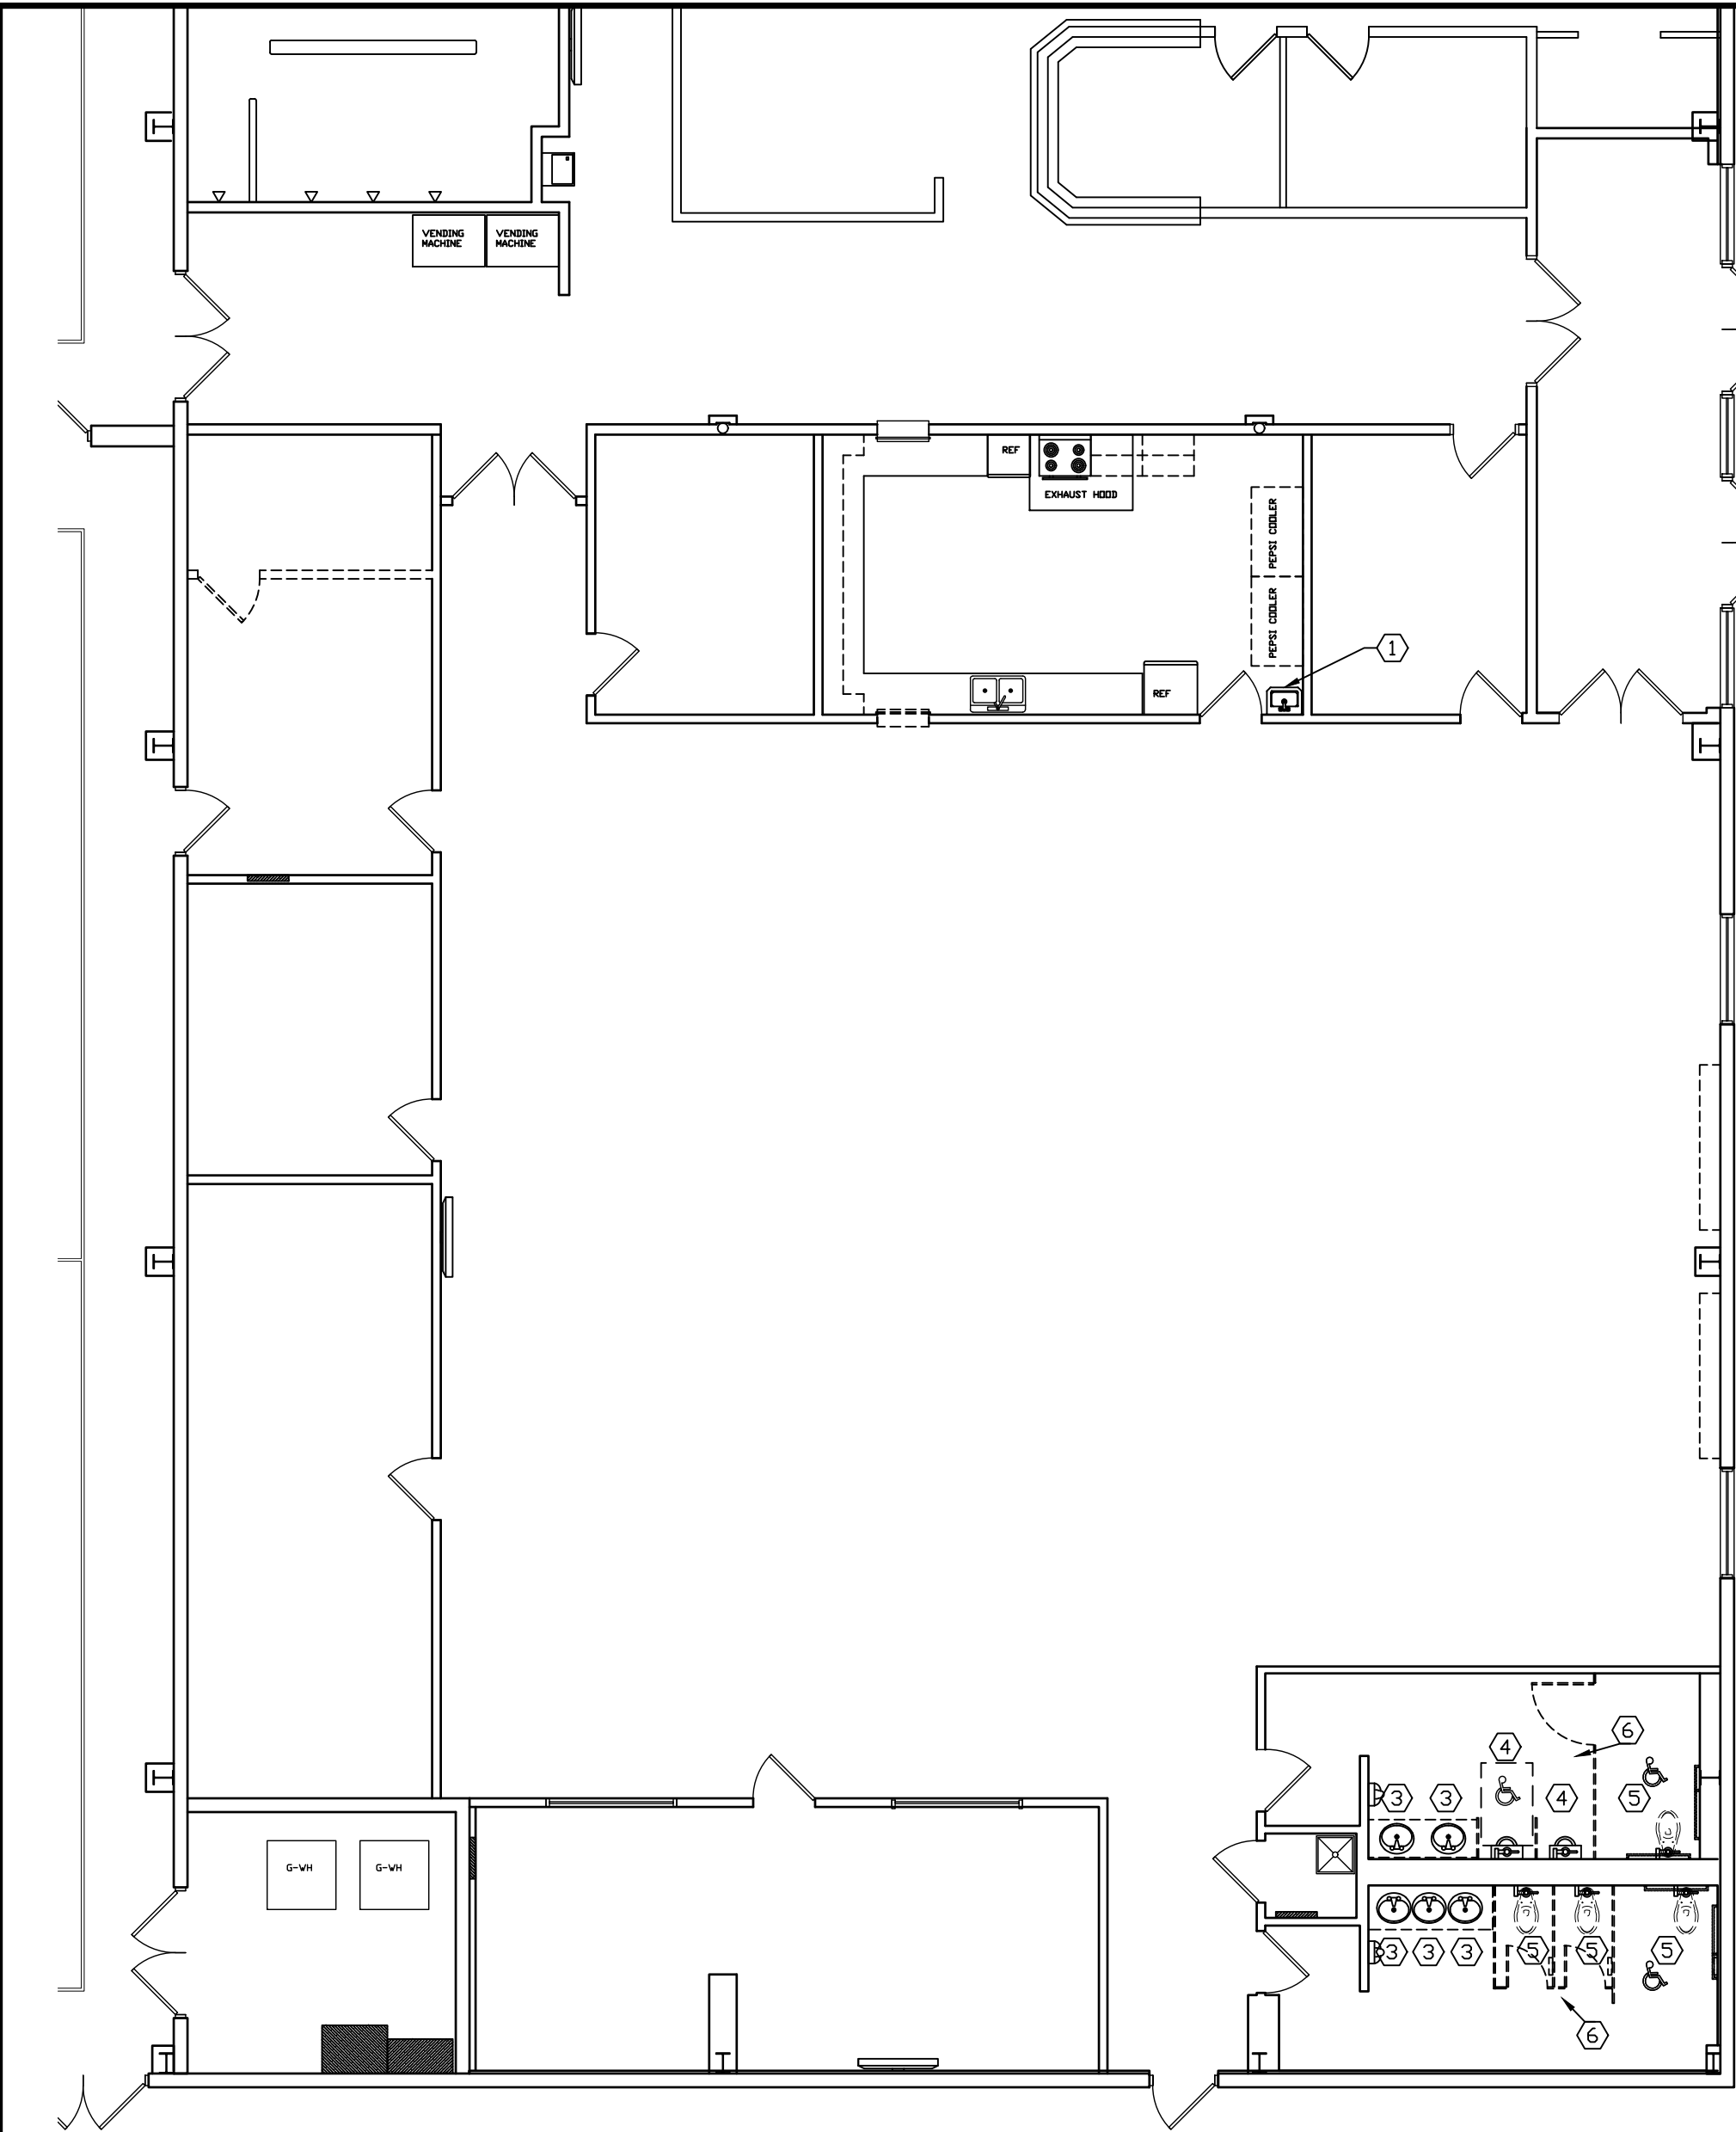

EXISTING/DEMOLITION PLUMBING PLAN
SCALE: 1/8" = 1'-0"

DEMOLITION NUMBERED NOTES:

- EXISTING WALL HUNG SINK TO REMAIN.
REMOVE EXISTING FAUCET.
REPAIR P-TRAP AND DRAIN LINE AS REQUIRED.
- NOT USED
- REMOVE EXISTING SINKS COMPLETE.
ADJUST WATER SUPPLY AND DRAIN ROUGH-INS
AS REQUIRED FOR NEW SINKS.
ALL GYPSUM WALL BOARD WILL BE REMOVED DURING
DEMOLITION.
- REMOVE EXISTING URINALS COMPLETE.
ADJUST WATER SUPPLY AND DRAIN ROUGH-INS
AS REQUIRED FOR NEW URINALS.
ALL GYPSUM WALL BOARD WILL BE REMOVED DURING
DEMOLITION.
- REMOVE EXISTING WATER CLOSETS COMPLETE.
ADJUST WATER SUPPLY ROUGH-INS
AS REQUIRED FOR NEW WATER CLOSETS.
ALL GYPSUM WALL BOARD WILL BE REMOVED DURING
DEMOLITION.
- REMOVE STRAINER ON EXISTING DRAIN BODY WHICH HAS
BEEN PAINTED.
PROVIDE AND INSTALL NEW STRAINER WITH HEEL PROOF
GRATE AFTER NEW FLOOR INSTALLATION.

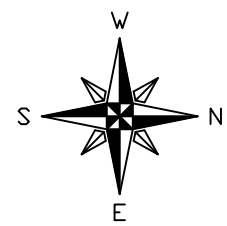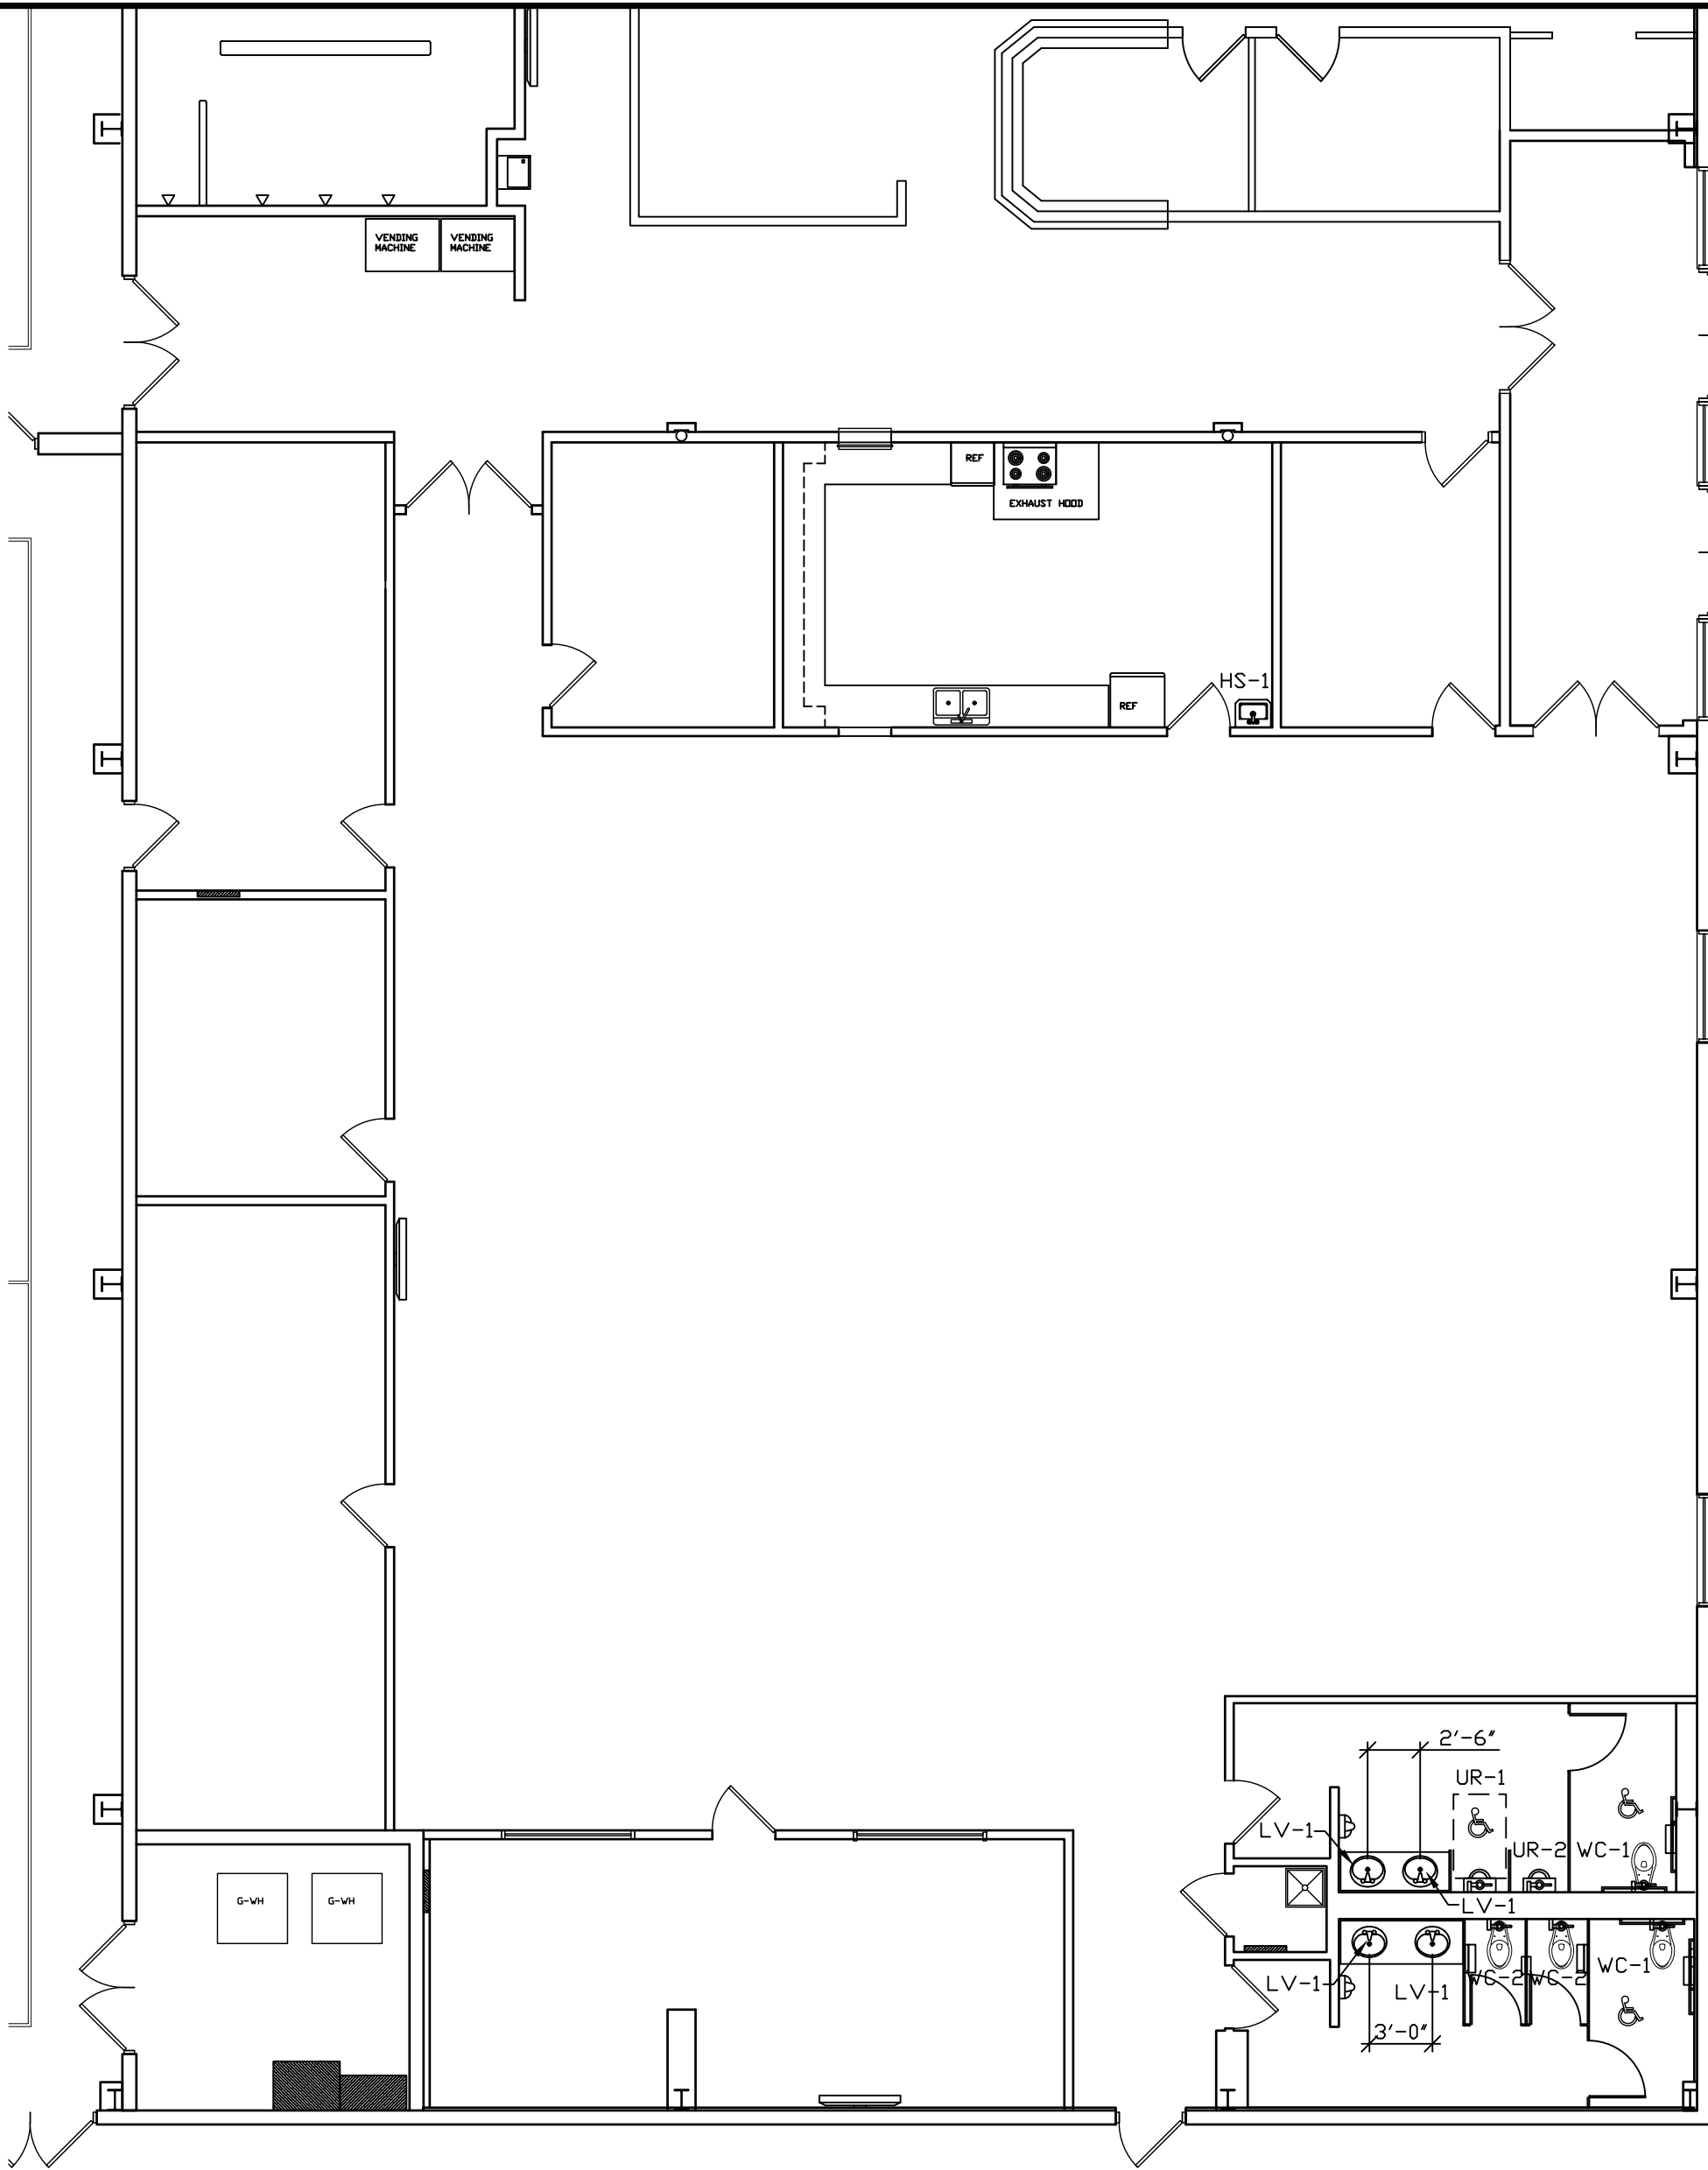

NEW PLUMBING FLOOR PLAN
SCALE: 1/8" = 1'-0"

NEW NUMBERED NOTES:

-

SYMBOL LEGEND:

- COLD WATER LINE
- HOT WATER LINE
- SANITARY VENT LINE
- SANITARY DRAIN LINE
- GAS LINE
- AIR LINE

GENERAL NOTES:

- ALL CONTRACTORS AND SUB-CONTRACTORS
SHALL REVIEW ALL DRAWINGS FOR WORK
PERFORMED BY THAT CONTRACTOR.
- ALL WALLS INDICATED ON THE
ARCHITECTURAL PLANS AS FIRE RATED SHALL
BE PROPERLY FIRE CAULKED FOR ALL
PENETRATIONS.

THE CONTENTS OF THIS DOCUMENT ARE THE SOLE PROPERTY OF
MICHAEL R. WALDBIESER ENGINEERING & CONSULTING, INC.
AND MAY NOT BE REPRODUCED OR TRANSFERRED IN ANY WAY
WITHOUT THE WRITTEN CONSENT OF MICHAEL R. WALDBIESER
ENGINEERING & CONSULTING, INC.
ALL REPORTS, PLANS, SPECIFICATIONS, COMPUTER FILES, FIELD
DATA, NOTES, AND OTHER DOCUMENTS AND INSTRUMENTS
PREPARED BY MICHAEL R. WALDBIESER ENGINEERING &
CONSULTING, INC. (DESIGN PROFESSIONAL) AS INSTRUMENTS OF
SERVICE SHALL REMAIN THE PROPERTY OF MICHAEL R.
WALDBIESER ENGINEERING & CONSULTING, INC. MICHAEL R.
WALDBIESER ENGINEERING & CONSULTING, INC. SHALL RETAIN
ALL COMMON LAW, STATUTORY, AND OTHER RESERVED RIGHTS,
INCLUDING THE COPYRIGHT THEREON. THIS STATEMENT SHALL
NOT BE REMOVED FROM THIS DRAWING FOR ANY REASON.

GENERAL MEP NOTE:
PLUMBING, MECHANICAL, AND ELECTRICAL CONTRACTORS TO ENSURE
COORDINATION OF EQUIPMENT AND MATERIALS INSTALLATION WITH OTHER
BUILDING COMPONENTS. ALL WORK SHALL BE DONE IN ACCORDANCE WITH
STATE, COUNTY, CITY BUILDING REGULATIONS AND CODES AS WELL AS
INDUSTRY STANDARD PRACTICE. THESE REQUIREMENTS ARE CONSIDERED
PART OF THE PLANS AND SPECIFICATIONS AND SHALL PREVAIL SHOULD
THEY DIFFER FROM THE PLANS AND SPECIFICATIONS. PRIOR TO BID
SUBMISSION, THE CONTRACTOR SHOULD DIRECT THE ENGINEER'S ATTENTION
TO ANY DISCREPANCY. SHOULD THE PRIME CONTRACTOR NOT SO NOTIFY
THE ENGINEER, THE CONTRACTORS SHALL FULLY COMPLY WITHOUT CLAIM
FOR EXTRA COSTS. REFER TO DRAWINGS FOR GOVERNING BUILDING CODES.

DATE	REVISIONS	BY



BIRD GIBSON SPORTS CENTER
599 SOUTH TABORTOWN ROAD
TERRE HAUTE, INDIANA 47803
2026 BUILDING REMODEL PHASE 1

MICHAEL R. WALDBIESER
ENGINEER & CONSULTING, INC.
STRUCTURAL, MECHANICAL, ELECTRICAL, PLUMBING

SYCAMORE BUILDING
19 SOUTH 66th STREET, SUITE 804
TERRE HAUTE, INDIANA 47807
PHONE: (812) 232-6510

SCALE: 1/8" = 1'-0"	PROJECT: 25-24
DATE: 07-13-26	FILE: PME #F
DRAWN BY: MRW	
APPROVED BY: MRW	

PROJECT: 25-24
FILE: PME #F

P1.0

PLUMBING FIXTURE SCHEDULE

SYMBOL	LOCATION	MODEL	DESCRIPTION	FAUCET / FLUSH VALVE	FITTINGS AND TRIM		PLUMBING FIXTURE PIPE SIZE				REMARKS
					FITTINGS MODEL	FITTING AND DESCRIPTION	WASTE	VENT	DCW	DHW	
WC-1	RESTROOM	AMERICAN STANDARD #3043.001	WATER CLOSET, MADERA FLOWISE 16 1/2" HEIGHT ELONGATED FLUSHOMETER TOILET, 1.1 TO 1.6 GPF, WHITE IN COLOR, FLOOR MOUNTED	SLOAN 111-1.1 1.1 GPF POLISHED CHROME FINISH, SINGLE FLUSH, WATER CLOSET FLUSHOMETER	BEMIS #296SSCT	WHITE COMMERCIAL HEAVY DUTY ELONGATED SEAT	3"	2"	1"	N/A	--
WC-2	RESTROOM	AMERICAN STANDARD #2234.001	WATER CLOSET, MADERA FLOWISE 19" HEIGHT ELONGATED FLUSHOMETER TOILET, 1.1 TO 1.6 GPF, WHITE IN COLOR, FLOOR MOUNTED	SLOAN 111-1.1 1.1 GPF POLISHED CHROME FINISH, SINGLE FLUSH, WATER CLOSET FLUSHOMETER	BEMIS #296SSCT	WHITE COMMERCIAL HEAVY DUTY ELONGATED SEAT	3"	2"	1"	N/A	--
UR-1	RESTROOM	AMERICAN STANDARD #C590.001.020	URINAL, WASHBROOK FLOWISE UNIVERSAL URINAL, .125 TO 1.0 GPF, WHITE IN COLOR SET AT ADA HANDICAP HEIGHT	SLOAN 196-0.5 0.5 GPF POLISHED CHROME FINISH, SINGLE FLUSH, URINAL FLUSHOMETER	-	--	2"	1 1/2"	3/4"	N/A	WITH WALL HANGERS AS REQUIRED SET AT ADA HANDICAPPED HEIGHT
UR-2	RESTROOM	AMERICAN STANDARD #C590.001.020	URINAL, WASHBROOK FLOWISE UNIVERSAL URINAL, .125 TO 1.0 GPF, WHITE IN COLOR	SLOAN 196-0.5 0.5 GPF POLISHED CHROME FINISH, SINGLE FLUSH, URINAL FLUSHOMETER	-	--	2"	1 1/2"	3/4"	N/A	WITH WALL HANGERS AS REQUIRED SET AT STANDARD HEIGHT
LV-1	RESTROOM	AMERICAN STANDARD #0476.028	LAVATORY, AQUALYN COUNTERTOP SINK SELF-RIMMING	CHICAGO 92-VE2805-765ABCP DECK MOUNTED METERING FAUCET CHROME FAUCET 0.5 GPM 4" FIXED CENTERS	-	--	1 1/4"	1 1/2"	1/2"	1/2"	SET IN COUNTERTOP WITH ANGLE STOPS WITH STAINLESS STEEL SUPPLY LINES WITH FLANGE DN SUPPLYS & WASTE WITH 1 1/4" CHROME PLATED P-TRAP WITH OFFSET GRID DRAIN
HS-1	CONCESSIONS	EXISTING SINK REMAINS	HAND WASH SINK, EXISTING	DELTA COMMERCIAL FAUCET #501LF-HGMHDF DECK MOUNTED CHROME FAUCET 0.5 GPM 4" FIXED CENTERS	TRUEBRO LAV GUARD2	--					WITH ANGLE STOPS - EXISTING WITH STAINLESS STEEL SUPPLY LINES
					-	--					NEW WITH FLANGE DN SUPPLYS & WASTE
					-	--					NEW WITH 1 1/2" CHROME PLATED P-TRAP

PLUMBING FIXTURE NOTES:

- ALL ANGLE SUPPLIES SHALL BE BRASS CRAFT G2 SERIES 1/4 TURN CHROME PLATED BRASS ANGLE STOPS.
- ALL SUPPLY LINES SHALL BE BRAIDED STAINLESS STEEL.
- ALL SUPPLY AND WASTE LINES SHALL HAVE ONE PIECE CHROME PLATED FLANGES AT WALL LINES.
- ALL P-TRAPS SHALL BE 17 GAUGE CHROME PLATED WITH CLEANOUTS IN BOTTOM OF TRAP.
- ALL FLOOR DRAINS SHALL HAVE 2" SURESEAL INLINE FLOOR DRAIN TRAP SEALER.

PLUMBING PIPING SPECIFICATIONS:

- SANITARY PIPING SHALL BE SDR35 PIPE MEETING ASTM-D3034.
- WASTE AND VENT PIPING SHALL BE SCH 40 PVC.
- ALL SANITARY PIPING AND VENT PIPING EXPOSED IN THE OPEN RETURN AIR HVAC PLENUM OF EACH FLOOR SHALL BE PROTECTED WITH PROTD CORP. LOSMOKE PVC JACKETING AND FITTINGS TO MEET THE REQUIRED FLAME SPREAD INDEX OF NOT MORE THAN 25 AND THE REQUIRED SMOKE DEVELOPED INDEX OF NOT MORE THAN 50. BOTH REQUIRED FOR ALL ITEMS LOCATED IN THE OPEN RETURN AIR HVAC PLENUM.
- WATER PIPING AS FOLLOWS:
 - ALL WATER PIPING IN THE BUILDING SHALL BE TYPE L HARD COPPER WITH PROGRESS FITTINGS AND INSULATED WITH 1" THICK KNAUF INSULATION EARTHWOOL 1000 PIPE INSULATION WITH ECUSE TECHNOLOGY. THIS INSULATION MAY BE EXPOSED IN THE OPEN RETURN AIR HVAC PLENUM IN THE BUILDING. FLAME SPREAD INDEX NOT MORE THAN 25. SMOKE DEVELOPED INDEX NOT MORE THAN 50.
 - GAS PIPING INSIDE BUILDING UNDER 2 1/2" IN SIZE SHALL BE BLACK STEEL, SCHEDULE 40, THREADED. ALL GAS PIPING 2 1/2" OR LARGER IN SIZE SHALL HAVE WELDED CONNECTIONS AND JOINTS.

SECTION 15200 - PLUMBING SPECIFICATIONS

PART 1: GENERAL The General Conditions and other Contract Documents are hereby made a part of this Section to the same extent as if written out in full.

- MANUFACTURER'S DESIGNATION When manufacturers catalog numbers are given, they are for assistance to the bidder. In case of discrepancies in catalog numbers, the Contractor shall contact the Engineer of Record.
- SUPERVISION The Plumbing Contractor shall at all times throughout the construction period, maintain proper supervision of his employees, make orderly disposition of his materials, maintain high-class workmanship, systematically remove debris, cooperate fully with other contractors and subcontractors and avoid the creation of hazards to others on the job.
- GUARANTEE The plumbing Contractor shall make good any defect due to faulty material or workmanship; he shall correct any malfunction not due to misuse or abuse after date of acceptance, which develops in his work, for a period of one (1) year from date of acceptance. The date of final payment shall be recognized as the date of acceptance.
- EQUIPMENT MARKING AND PAINTING All marred or scratched equipment shall be touched up with same paint as that damaged. Steel and iron shall have grease, rust scale and dirt removed and left in a paintable condition. Painting will be done by General Contractor.
- RULES, REGULATIONS AND PERMITS All materials, workmanship, and installation shall conform to all local and state codes and federal O.S.H.A. standards. This Plumbing Contractor shall, at his own expense, furnish all necessary permits and fees required by the Local Ordinances and by the State of Indiana for construction and inspection of work installed by him. Refer to drawings for specific enforceable Building Codes. This includes all sanitary sewer tap fees and domestic water tap fees charged by local utilities.
- TEMPORARY SERVICES The Plumbing Contractor shall furnish and install a temporary water service. A water outlet shall be provided at a location convenient for general use, and an outlet shall be provided on each floor of the building. The General Contractor will pay for the water used.
- SYSTEM SCHEDULE Systems shall include, but not be limited to:
 - Water Service and Supply System - connect as shown on the drawings
 - Sanitary Sewer Piping - connect as shown on the drawings
 - Waste and Vent Piping
 - Plumbing Fixtures - water closets, lavatories, faucets, floor drains, sinks, etc.

- PART 2: MATERIALS AND METHODS
- PRODUCTS See drawings for model numbers and specifications.
 - PLUMBING PLAN The Plumbing Contractor shall use the accompanying drawings as his working drawings except that deviations may be made only where inferences may arise. Such deviations shall be called to the attention of the Engineer and prior approval obtained before making any installation. In no case shall codes, rules or regulations hereinbefore referred to be violated.
 - DRAWINGS The Plumbing Contractor shall furnish "Shop Drawings" for all equipment supplied on this project. He shall obtain, ahead of job progress, all manufacturer's drawings, wiring diagrams, rough-in location drawings, operating instructions, etc., for each item of equipment furnished and set by him and connected to by other contractors. He shall see that the other contractors who connect to his equipment have the necessary drawings for rough-in and wiring diagrams ahead of their job progress. The Plumbing Contractor shall also maintain a complete set of General, structural, electrical and mechanical drawings during the progress of the job. He shall also maintain a clean set of mechanical drawings for record purposes, upon which he shall mark, legibly, all deviations from the Contract Documents. This set shall be turned over to the Engineer at the termination of the job for an "As Built" set.
 - PIPE AND FITTINGS All fittings shall be cast brass or wrought copper fittings. All joints shall be made in accordance with instructions of the manufacturer of the fittings. Proper adapters and unions shall be used at connections to steel or iron pipe or equipment. Fittings for gas piping inside the building shall be black, malleable, threaded.
 - WATER SUPPLY SYSTEM System Description. The Plumbing Contractor shall install a complete system of cold water, hot water and hot water return as shown on the drawings. All fixtures shall have appropriate services connected. The complete system shall be pitched for drainage to low points and drain valves installed at each low point. All piping shall be run as high as possible. Check valves shall be installed where necessary to prevent hot water from backing up into cold water. All branches shall be valved at take-off from mains. Each branch to riser shall be provided with stop and waste. All vertical pipe shall be supported where it passes through floors with an approved clamping device. All risers shall be securely fastened to floors and wall studs with any change from vertical supported by brackets or hangers in it's new position. All piping shall be run true and straight and at right angles or parallel to walls. In all cases the exposed pipe must be run straight and plumb and in no case to be farther from walls and ceilings than is absolutely necessary. All exposed connections to fixtures shall be chrome plated brass. Wherever an exposed pipe passes through finished walls or ceilings it shall be provided with a chrome plated solid ring escutcheon. If pipe is covered, escutcheon shall fit over insulation. Connections to fixtures shall be made with unions so that a fixture may be easily removed and reset without making new joints. Provide and install easily accessible stops for all fixtures. All pipe shall be thoroughly cleaned of grease, oil and foreign material before installation. All cuts and threads shall be thoroughly cleaned and reamed to remove shoulders and burrs before installation. Wherever piping materials change from copper to a dissimilar metal, a dielectric union shall be installed.
 - SANITARY SEWER PIPING System Description. The Plumbing Contractor shall install a complete and continuous system of soil, waste and vent piping as shown on the drawings. All openings for connections must be closed with new plugs or other means until used, all hand holes must be closed at once, and the pipe must be kept clean. Any earth or foreign matter that gets into the pipes must be removed by the contractor. Vent pipes shall extend at least 12" above the roof and extensions through the roof shall not be smaller than 3" in accordance with state code. Vents in outside walls are to be offset at least 12" inside of the wall before extending through the roof. Vents shall be offset in attic as indicated on the drawings before going through the roof to provide a minimum separation of 10'-0" from outside air intakes of furnaces. All horizontal waste and vent lines, branches, drains, etc., shall pitch at 1/8" per foot unless otherwise noted on the drawings. Waste lines shall pitch downward in the direction of flow. Vent lines shall pitch upward in the direction of venting. All junctions and changes in direction shall be made by the appropriate use of 45 degree Wyes, half Wyes, long sweep quarter bends, sixth eighth, sixteenth bends, combination Wye and eight bends, except that single and double Sanitary Tees may be used on vertical stacks and short quarter bends may be used where the change in direction of flow is from horizontal to vertical. Tees and crosses may be used in vent piping only. All vertical stacks (waste and vent) shall be supported wherever they pass through floors with an approved clamping device. All piping shall be run true and straight and at right angles or parallel to walls. Cleanouts shall be full size of the pipe up to 4" in diameter and not less than 4" for larger size pipe. In all cases the exposed pipe must be run straight and plumb and in no case to be farther from walls and ceilings than is absolutely necessary. Each and every fixture included in the contract must have a separate trap, except where noted otherwise on the drawings. Floor and Area Drains. The Plumbing Contractor shall furnish and install floor and area drains complete with traps and cleanouts as specified.
 - GAS PIPING SYSTEM System Description. The Plumbing Contractor shall furnish and install a complete system of gas distribution as shown on the drawings. The installation shall be included as a part of this Contract and shall be installed per the Codes. Dielectric unions shall be installed between the gas meter the piping in the building. Piping inside the building shall be run true and straight and shall be pitched to dirt pockets where required. The Plumbing Contractor shall make final connections to all equipment requiring gas service as shown on the drawings. All piping inside the building shall have screwed joints except that all gas piping 2 1/2" or larger shall have welded joints. Pipe shall be reamed to remove shoulders and burrs and all threads and the pipe cleaned before erection.
 - TESTS General. The Plumbing Contractor shall furnish all labor and material necessary to perform the following tests. Tests may be performed in sections of the Systems as they are installed so as not to hold up construction. The Engineer shall be notified whenever such tests are to be made and shall witness all tests. Water Supply System. The Water Supply System shall be filled with water and subjected to a pressure of at least 150 PSIG per section under test. Pressure shall be obtained by use of an air compressor. Pressure shall hold for a period of one (1) hour without any additional pressure being applied. Soil and Waste System. The Soil, Waste and Vent System shall be subjected to a hydrostatic test by plugging or closing all holes in portion of the system under test and filling with water to a point twelve (12) feet higher than the highest pipe under test. Water level shall hold for a minimum of 24 hours without change in the water level with no additional water being applied. The Engineer may elect to shorten the test period due to freezing weather conditions. It shall be his prerogative. Gas Piping System. The Gas Piping system shall be subjected to an air pressure test of at least 150 PSIG and shall hold pressure for a period of 24 hours without any additional pressure being applied. Pressure shall be obtained from an air compressor. Each joint shall be soap tested to test for leaks.

PART 3: EXECUTION

The contractor must lay out the various pipe lines, as shown on the drawings, and carefully go over the work in the building and report to the Michael R. Waldbieser Engineering & Consulting, Inc. any obstacles that may be in the way to prevent proper run of pipes or interfere with the layout of the system in any way. All pipes included in the plumbing system must be run in such a manner as to not interfere with HVAC ductwork or electrical outlets. All work on this project must be complete of all parts and supplies and hook-ups to make a complete operating job when the project is finished. All equipment shall be provided and installed in strict accordance with the manufacturer's installation instructions. Compaction of soil shall be as stated in the General Written Specifications for all trenching. All trenching required for installation of products specified in this section of work shall be done by the Plumbing Contractor. Backfilling after trenching shall be done in accordance with the General Written Specifications by the Plumbing Contractor. After backfilling, the Plumbing Contractor shall finish grade the area disturbed by the trenching to match that of the site prior to trenching.

END OF SECTION

SYMBOL LEGEND:

- COLD WATER LINE
- HOT WATER LINE
- SANITARY VENT LINE
- SANITARY DRAIN LINE
- GAS
- AIR LINE

GENERAL NOTES:

- ALL CONTRACTORS AND SUB-CONTRACTORS SHALL REVIEW ALL DRAWINGS FOR WORK PERFORMED BY THAT CONTRACTOR.
- ALL WALLS INDICATED ON THE ARCHITECTURAL PLANS AS FIRE RATED SHALL BE PROPERLY FIRE CAULKED FOR ALL PENETRATIONS.

THE CONTENTS OF THIS DOCUMENT ARE THE SOLE PROPERTY OF MICHAEL R. WALDBIESER ENGINEERING & CONSULTING, INC. AND MAY NOT BE REPRODUCED OR TRANSFERRED IN ANY WAY WITHOUT THE WRITTEN CONSENT OF MICHAEL R. WALDBIESER ENGINEERING & CONSULTING, INC. ALL REPORTS, PLANS, SPECIFICATIONS, COMPUTER FILES, FIELD DATA, NOTES, AND OTHER DOCUMENTS AND INSTRUMENTS PREPARED BY MICHAEL R. WALDBIESER ENGINEERING & CONSULTING, INC. (DESIGN PROFESSIONAL) AS INSTRUMENTS OF SERVICE SHALL REMAIN THE PROPERTY OF MICHAEL R. WALDBIESER ENGINEERING & CONSULTING, INC. MICHAEL R. WALDBIESER ENGINEERING & CONSULTING, INC. SHALL RETAIN ALL COMMON LAW, STATUTORY, AND OTHER RESERVED RIGHTS, INCLUDING THE COPYRIGHT THERETO. THIS STATEMENT SHALL NOT BE REMOVED FROM THIS DRAWING FOR ANY REASON.

GOVERNING CODES

- 2014 INDIANA BUILDING CODE (IBC 2012 EDITION - WITH INDIANA AMENDMENTS)
- 2014 INDIANA FIRE CODE (IFC 2012 EDITION - WITH INDIANA AMENDMENTS)
- 2012 INDIANA PLUMBING CODE (IPC 2006 EDITION - WITH INDIANA AMENDMENTS)
- 2014 INDIANA MECHANICAL CODE (IMC 2012 EDITION - WITH INDIANA AMENDMENTS)
- 2010 INDIANA ENERGY CONSERVATION CODE (ANSI/ASHRAE 90.1 - 2007 EDITION - WITH INDIANA AMENDMENTS)
- 2009 INDIANA ELECTRICAL CODE (NEC 2008 EDITION - WITH INDIANA AMENDMENTS)

GENERAL MEP NOTE:
PLUMBING, MECHANICAL, AND ELECTRICAL CONTRACTORS TO ENSURE COORDINATION OF EQUIPMENT AND MATERIALS INSTALLATION WITH OTHER BUILDING COMPONENTS. ALL WORK SHALL BE DONE IN ACCORDANCE WITH STATE, COUNTY, CITY BUILDING REGULATIONS AND CODES AS WELL AS INDUSTRY STANDARD PRACTICE. THESE REQUIREMENTS ARE CONSIDERED PART OF THE PLANS AND SPECIFICATIONS AND SHALL PREVAIL SHOULD THEY DIFFER FROM THE PLANS AND SPECIFICATIONS. PRIOR TO BID SUBMISSION, THE CONTRACTOR SHOULD DIRECT THE ENGINEER'S ATTENTION TO ANY DISCREPANCY. SHOULD THE PRIME CONTRACTOR NOT SO NOTIFY THE ENGINEER, THE CONTRACTORS SHALL FULLY COMPLY WITHOUT CLAIM FOR EXTRA COSTS. REFER TO DRAWINGS FOR GOVERNING BUILDING CODES.

DATE	REVISIONS	BY



BIRD GIBSON SPORTS CENTER
599 SOUTH TABORTOWN ROAD
TERRE HAUTE, INDIANA 47803
2026 BUILDING REMODEL PHASE 1

MICHAEL R. WALDBIESER
ENGINEER & CONSULTING, INC.
STRUCTURAL, MECHANICAL, ELECTRICAL, PLUMBING



SYCAMORE BUILDING
19 SOUTH 66th STREET, SUITE 804
TERRE HAUTE, INDIANA 47807

PHONE: (812) 232-6510

SCALE: NONE	DATE: 07-13-26	DRAWN BY: MRW	APPROVED BY: MRW
-------------	----------------	---------------	------------------

PROJECT: 25-24
FILE: PME #F



P2.0

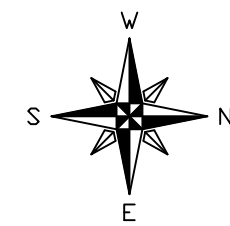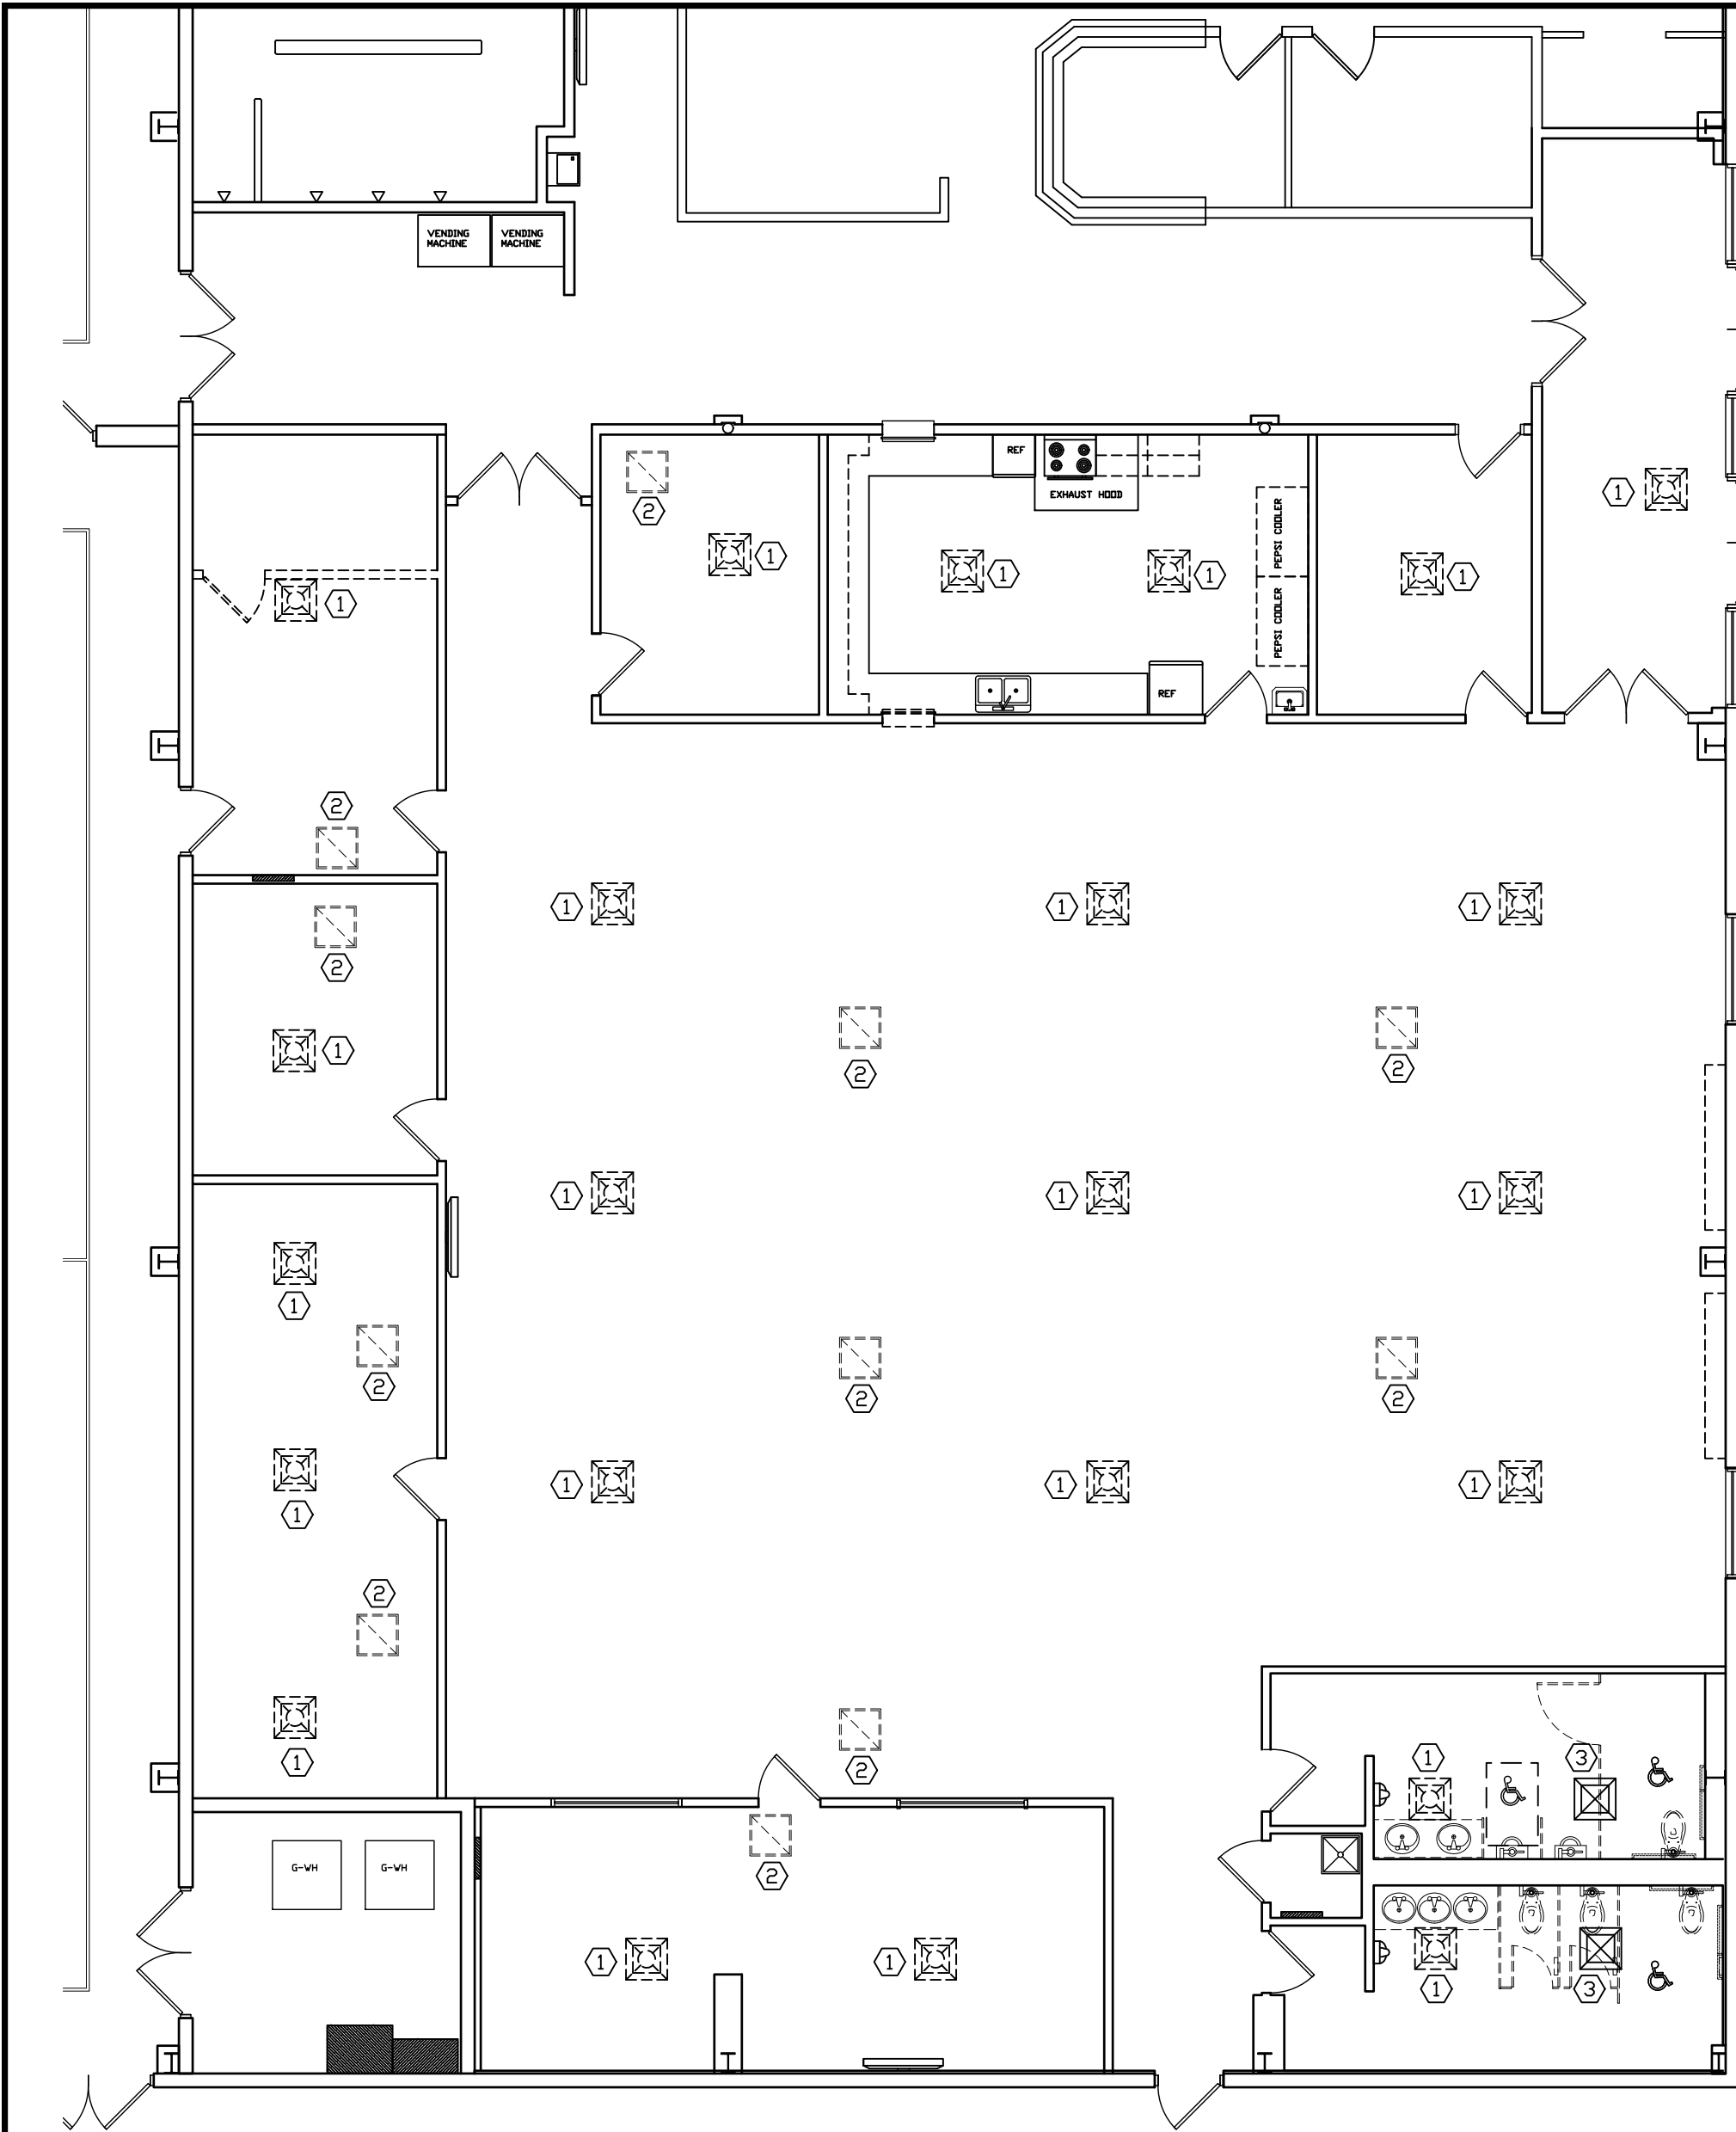

EXISTING/DEMOLITION MECHANICAL PLAN
SCALE: 1/8" = 1'-0"

NUMBERED NOTES:

- 1 REMOVE EXISTING HVAC SUPPLY AIR GRILLE COMPLETE. WILL BE REPLACED AND RELOCATED TO NEW LOCATION.
- 2 REMOVE EXISTING HVAC RETURN AIR GRILLE COMPLETE. WILL BE REPLACED AND RELOCATED TO NEW LOCATION.
- 3 REMOVE EXISTING EXHAUST FAN GRILLE COMPLETE. WILL BE REPLACED AND RELOCATED TO NEW LOCATION.

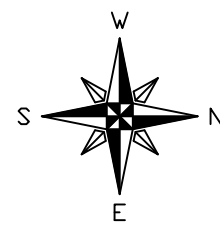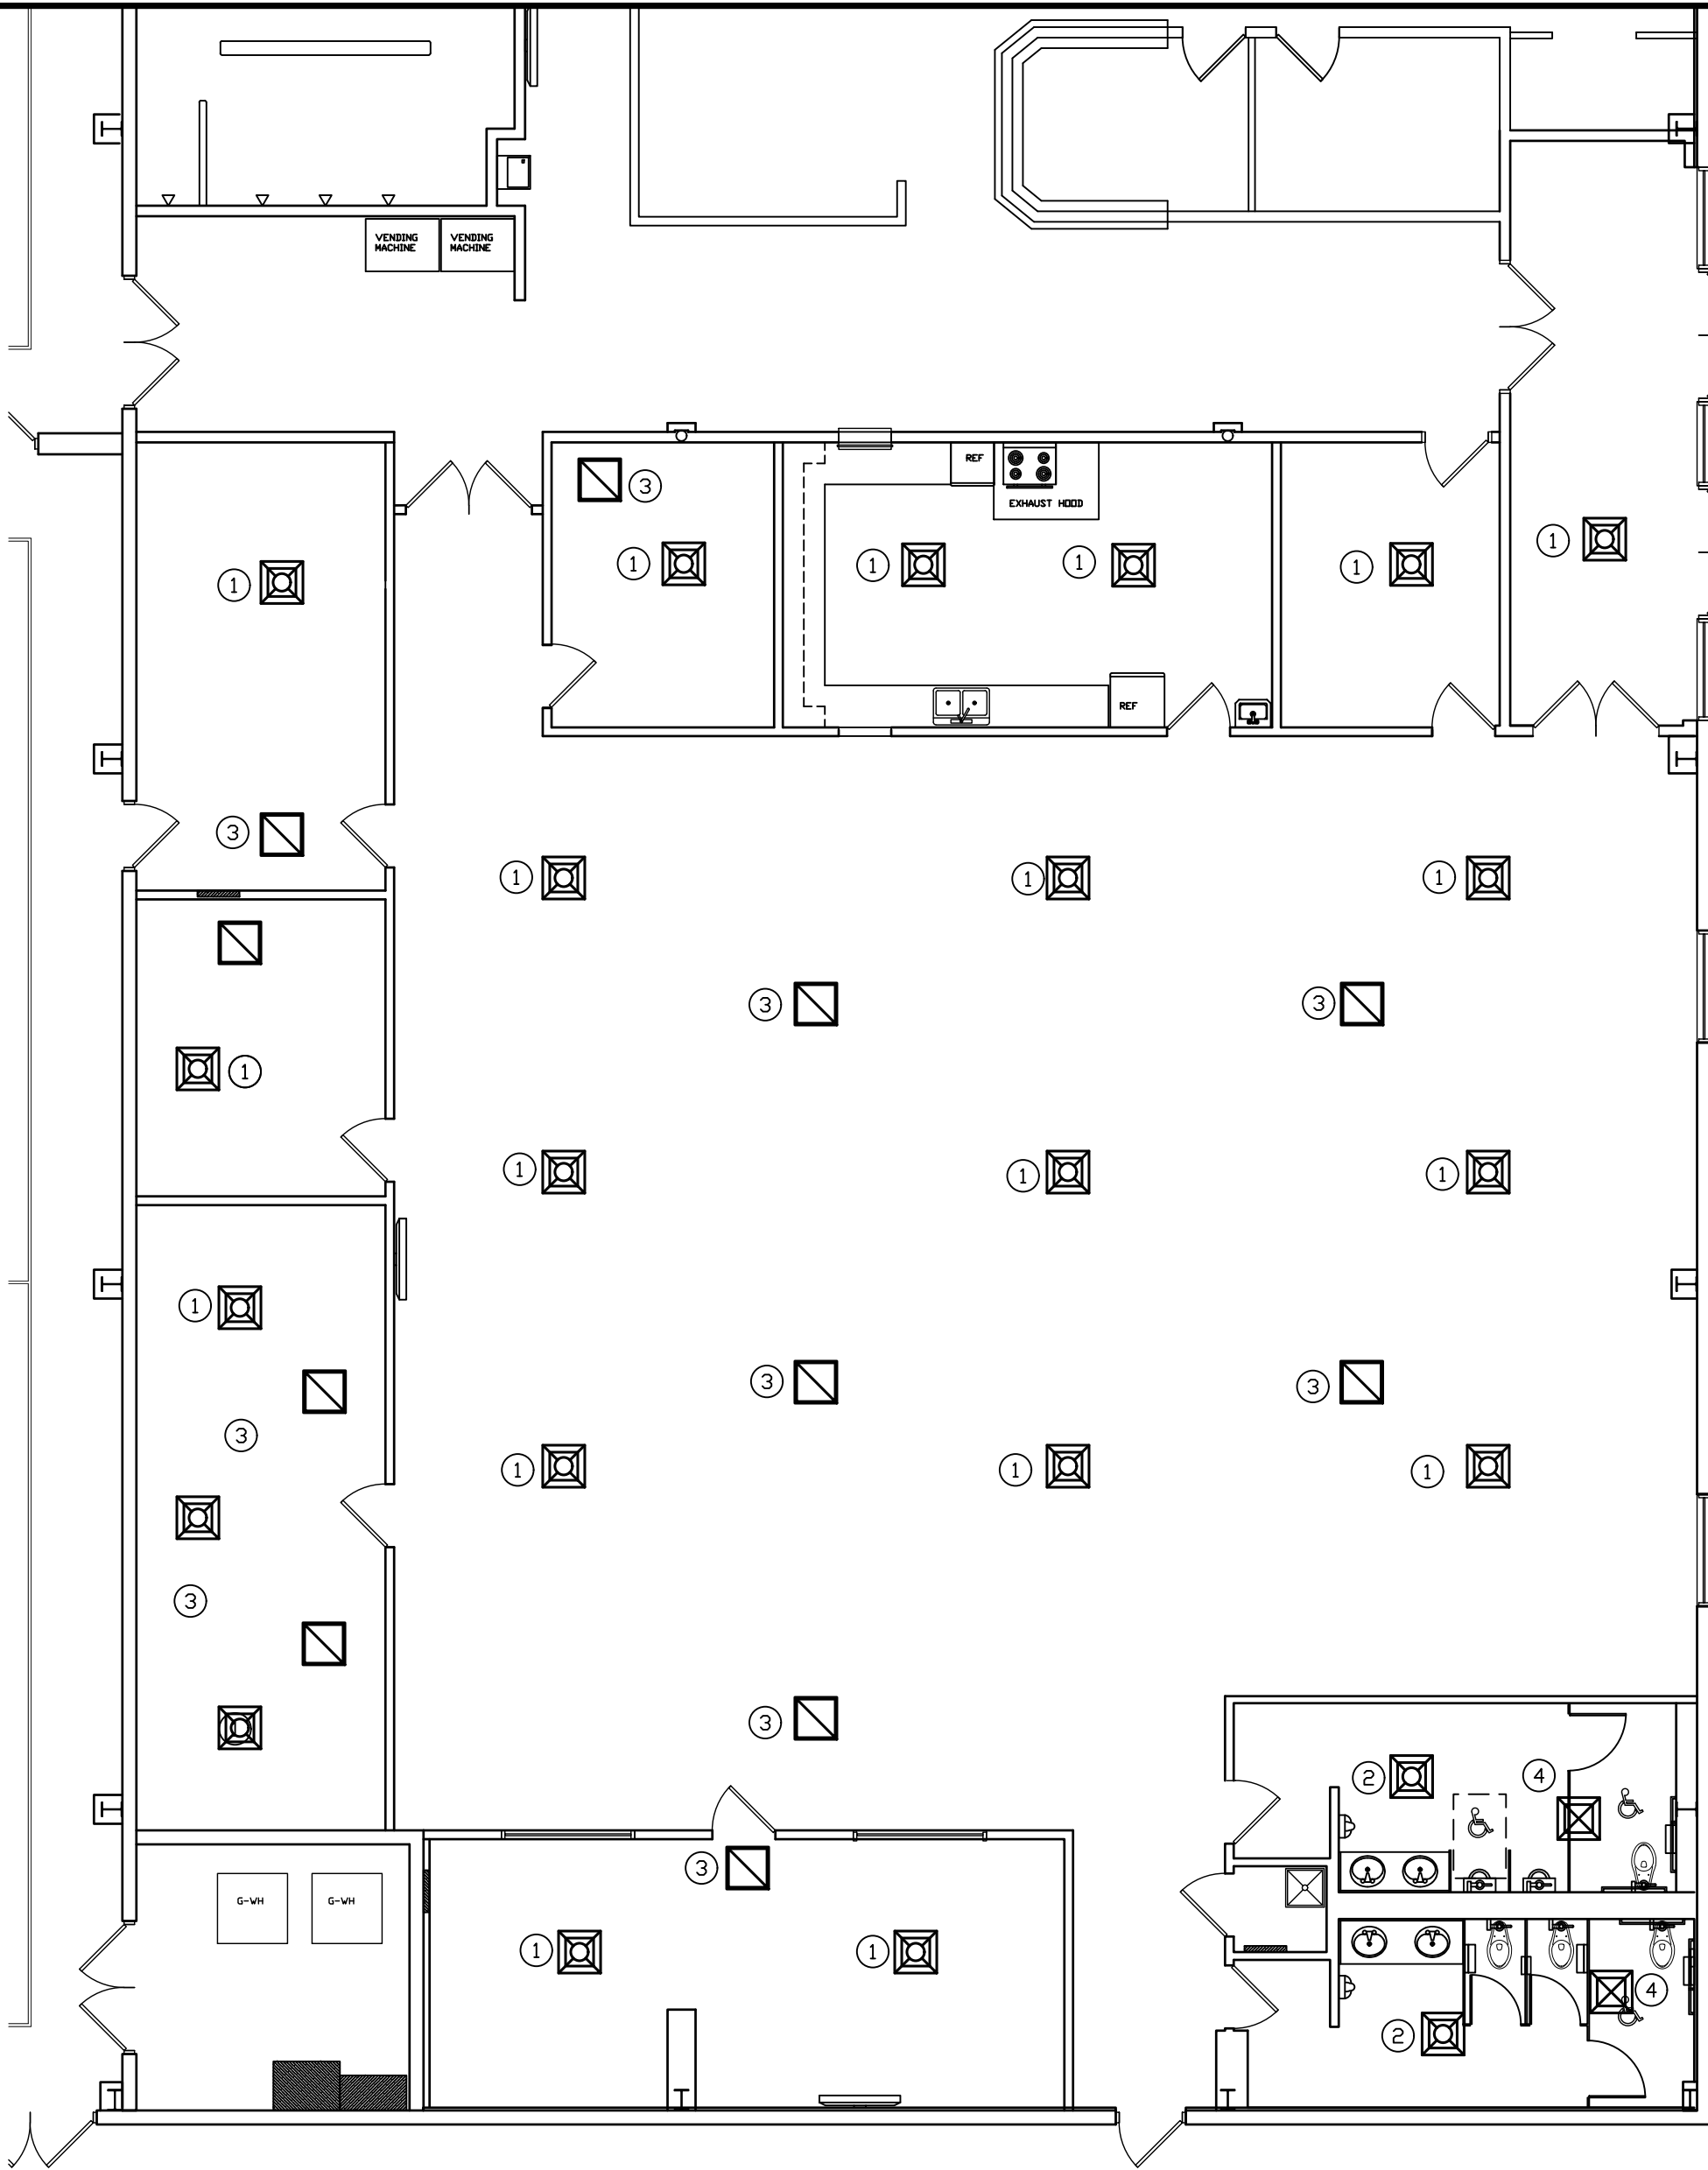

NEW MECHANICAL FLOOR PLAN
SCALE: 1/8" = 1'-0"

NEW NUMBERED NOTES:

- 1 NEW HVAC SUPPLY AIR GRILLE. TITUS TMS - WHITE IN COLOR. STEEL CONSTRUCTION. FIELD VERIFY SIZE AND MATCH. EXTEND DUCTWORK AS REQUIRED TO ALLOW FOR PLACEMENT AT NEW LOCATION.
- 2 NEW HVAC SUPPLY AIR GRILLE. TITUS TMS-AA - WHITE IN COLOR. ALUMINUM CONSTRUCTION. FIELD VERIFY SIZE AND MATCH. EXTEND DUCTWORK AS REQUIRED TO ALLOW FOR PLACEMENT AT NEW LOCATION.
- 3 NEW HVAC RETURN AIR GRILLE. TITUS 50F - ALUMINUM BORDER AND CORE. FIELD VERIFY SIZE AND MATCH. OPEN RETURN AIR SYSTEM SO NO DUCTWORK ATTACHMENT OR BACK BOX IS REQUIRED.
- 4 NEW HVAC EXHAUST AIR GRILLE. TITUS 50F - ALUMINUM BORDER AND CORE. FIELD VERIFY SIZE AND MATCH.

GENERAL MEP NOTE:
PLUMBING, MECHANICAL, AND ELECTRICAL CONTRACTORS TO ENSURE COORDINATION OF EQUIPMENT AND MATERIALS INSTALLATION WITH OTHER BUILDING COMPONENTS. ALL WORK SHALL BE DONE IN ACCORDANCE WITH STATE, COUNTY, CITY BUILDING REGULATIONS AND CODES AS WELL AS INDUSTRY STANDARD PRACTICE. THESE REQUIREMENTS ARE CONSIDERED PART OF THE PLANS AND SPECIFICATIONS AND SHALL PREVAIL SHOULD THEY DIFFER FROM THE PLANS AND SPECIFICATIONS. PRIOR TO BID SUBMISSION, THE CONTRACTOR SHOULD DIRECT THE ENGINEER'S ATTENTION TO ANY DISCREPANCY. SHOULD THE PRIME CONTRACTOR NOT SO NOTIFY THE ENGINEER, THE CONTRACTORS SHALL FULLY COMPLY WITHOUT CLAIM FOR EXTRA COSTS. REFER TO DRAWINGS FOR GOVERNING BUILDING CODES.

GOVERNING CODES

2014 INDIANA BUILDING CODE
(IBC 2012 EDITION - WITH INDIANA AMENDMENTS)
2014 INDIANA FIRE CODE
(IFC 2012 EDITION - WITH INDIANA AMENDMENTS)
2012 INDIANA PLUMBING CODE
(IPC 2006 EDITION - WITH INDIANA AMENDMENTS)
2014 INDIANA MECHANICAL CODE
(IMC 2012 EDITION - WITH INDIANA AMENDMENTS)
2010 INDIANA ENERGY CONSERVATION CODE
(ANSI/ASHRAE 90.1 - 2007 EDITION - WITH INDIANA AMENDMENTS)
2009 INDIANA ELECTRICAL CODE
(NEC 2008 EDITION - WITH INDIANA AMENDMENTS)

GENERAL NOTES:

1. ALL CONTRACTORS AND SUB-CONTRACTORS SHALL REVIEW ALL DRAWINGS FOR WORK PERFORMED BY THAT CONTRACTOR.
2. ALL WALLS INDICATED ON THE ARCHITECTURAL PLANS AS FIRE RATED SHALL BE PROPERLY FIRE CAULKED FOR ALL PENETRATIONS.

THE CONTENTS OF THIS DOCUMENT ARE THE SOLE PROPERTY OF MICHAEL R. WALDBIESER ENGINEERING & CONSULTING, INC. AND MAY NOT BE REPRODUCED OR TRANSFERRED IN ANY WAY WITHOUT THE WRITTEN CONSENT OF MICHAEL R. WALDBIESER ENGINEERING & CONSULTING, INC.
ALL REPORTS, PLANS, SPECIFICATIONS, COMPUTER FILES, FIELD DATA, NOTES, AND OTHER DOCUMENTS AND INSTRUMENTS PREPARED BY MICHAEL R. WALDBIESER ENGINEERING & CONSULTING, INC. (DESIGN PROFESSIONAL) AS INSTRUMENTS OF SERVICE SHALL REMAIN THE PROPERTY OF MICHAEL R. WALDBIESER ENGINEERING & CONSULTING, INC. MICHAEL R. WALDBIESER ENGINEERING & CONSULTING, INC. SHALL RETAIN ALL COMMON LAW, STATUTORY, AND OTHER RESERVED RIGHTS, INCLUDING THE COPYRIGHT THERETO. THIS STATEMENT SHALL NOT BE REMOVED FROM THIS DRAWING FOR ANY REASON.

DATE	REVISIONS	BY



BIRD GIBSON SPORTS CENTER
599 SOUTH TABORTOWN ROAD
TERRE HAUTE, INDIANA 47803
2026 BUILDING REMODEL PHASE 1

MICHAEL R. WALDBIESER
ENGINEER & CONSULTING, INC.
STRUCTURAL, MECHANICAL, ELECTRICAL, PLUMBING


PHONE: (812) 232-6510

SYCAMORE BUILDING
19 SOUTH 66th STREET, SUITE 804
TERRE HAUTE, INDIANA 47807

SCALE: 1/8" = 1'-0"
DATE: 07-13-26
DRAWN BY: MRW
APPROVED BY: MRW

PROJECT: 25-24
FILE: PME #F

M1.0

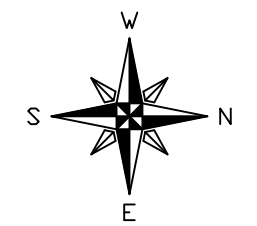



EXISTING/DEMOLITION ELECTRICAL PLAN
SCALE: 1/8" = 1'-0"

DATA / TELECOM SCHEDULE	
▼	EXISTING DATA DROP TO REMAIN
▽	EXISTING TELEPHONE DROP TO REMAIN
▼	EXISTING COMBINATION DATA / TELEPHONE DROP TO REMAIN
●	EXISTING SPEAKER LOCATION. REMOVE, STORE, AND REPLACE PER NEW CEILING LAYOUT

GENERAL MEP NOTE:
PLUMBING, MECHANICAL, AND ELECTRICAL CONTRACTORS TO ENSURE COORDINATION OF EQUIPMENT AND MATERIALS INSTALLATION WITH OTHER BUILDING COMPONENTS. ALL WORK SHALL BE DONE IN ACCORDANCE WITH STATE, COUNTY, CITY BUILDING REGULATIONS AND CODES AS WELL AS INDUSTRY STANDARD PRACTICE. THESE REQUIREMENTS ARE CONSIDERED PART OF THE PLANS AND SPECIFICATIONS AND SHALL PREVAIL SHOULD THEY DIFFER FROM THE PLANS AND SPECIFICATIONS. PRIOR TO BID SUBMISSION, THE CONTRACTOR SHOULD DIRECT THE ENGINEER'S ATTENTION TO ANY DISCREPANCY. SHOULD THE PRIME CONTRACTOR NOT SO NOTIFY THE ENGINEER, THE CONTRACTORS SHALL FULLY COMPLY WITHOUT CLAIM FOR EXTRA COSTS. REFER TO DRAWINGS FOR GOVERNING BUILDING CODES.

DEMOLITION NUMBERED NOTES:

1. THE FOLLOWING ITEMS SHALL BE REMOVED COMPLETE AND DISPOSED OF BY THE ELECTRICAL CONTRACTOR INSIDE THE AREA INDICATED:
 1. ALL LIGHT FIXTURES
 2. ALL EMERGENCY LIGHTING AND EXIT SIGNS
 3. ALL RECEPTACLES AND COVER PLATES
 4. ALL SWITCHES AND COVER PLATES
 5. ALL FAN CONTROLS AND COVER PLATES
2. THE FOLLOWING ITEMS SHALL BE REMOVED BY THE ELECTRICAL CONTRACTOR AND STORED FOR RE-INSTALLATION:
 1. CEILING SPEAKERS
 2. AND FIRE ALARM ITEMS
3. REMOVE EXISTING ELECTRIC HAND DRYER. RE-INSTALL AFTER NEW GYPSUM BOARD IS INSTALLED AND PAINTED.

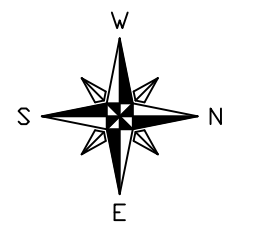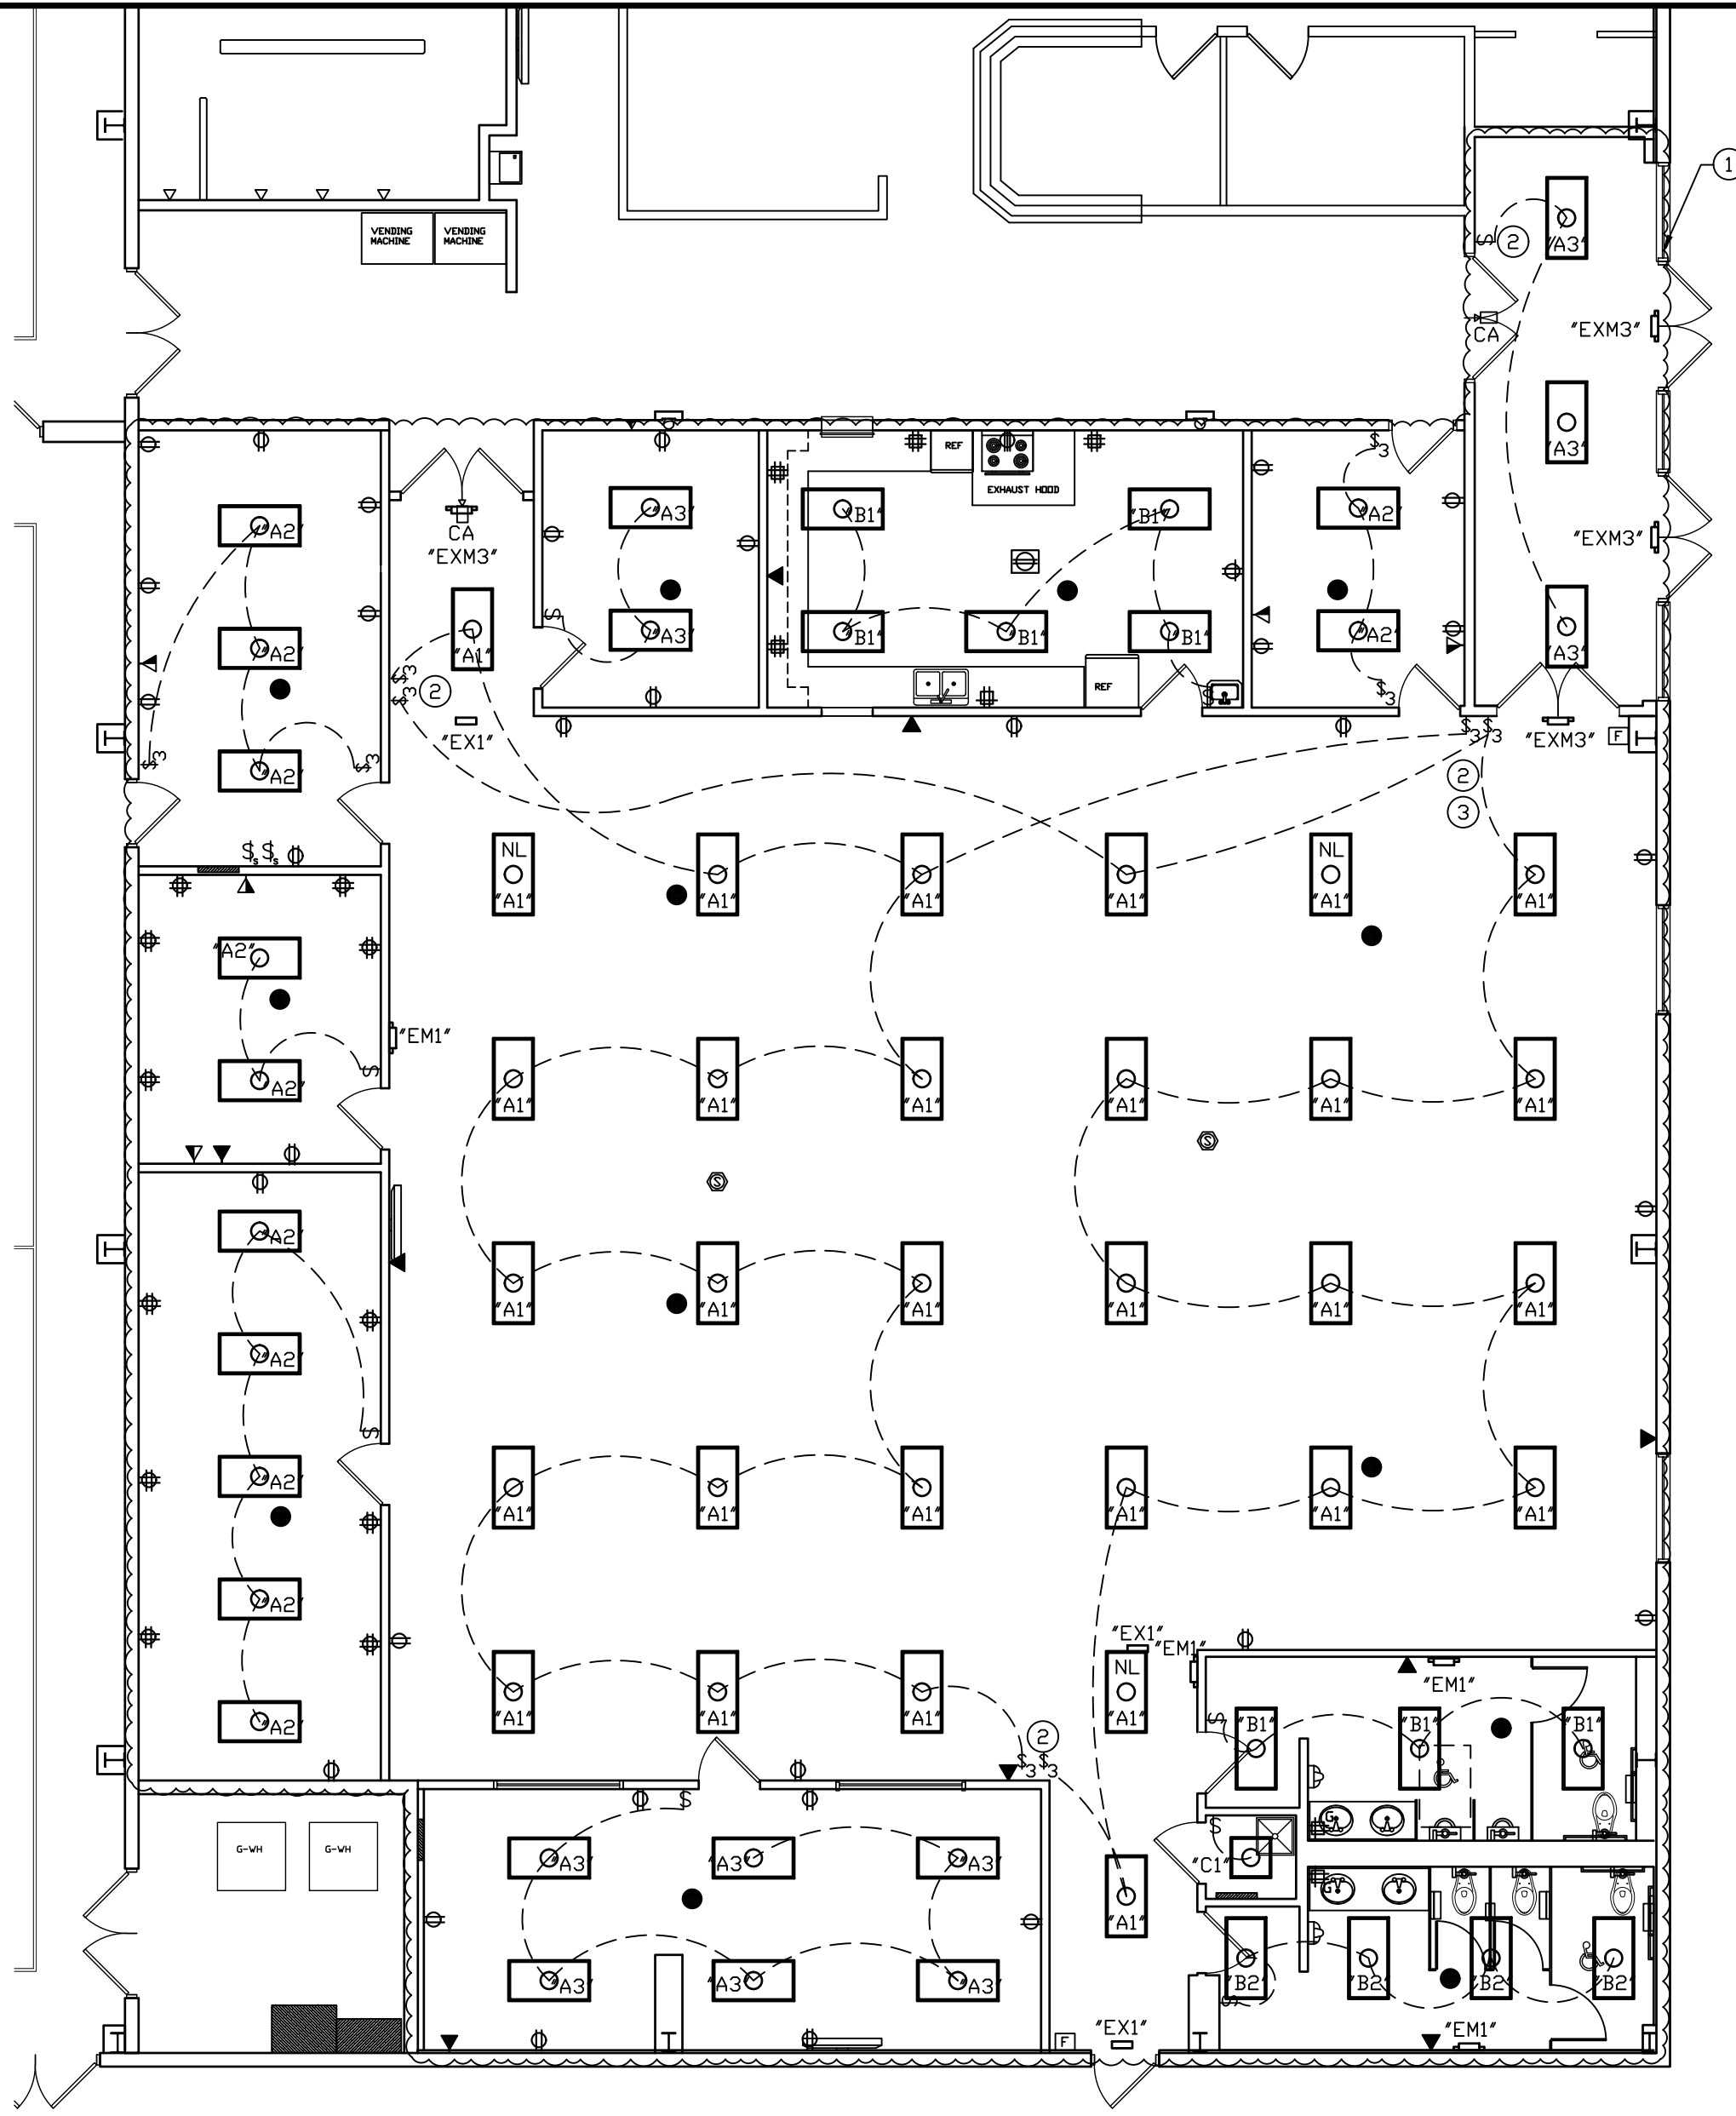

NEW ELECTRICAL PLAN
SCALE: 1/8" = 1'-0"

GENERAL NOTES:

1. THE SPACE ABOVE THE SUSPENDED CEILING IS AN OPEN RETURN AIR PLENUM FOR THE HVAC SYSTEM.
ALL NEW WIRING SHALL BE THHN CU IN MC CABLE.
ALL NEW SPEAKER WIRING SHALL BE PLENUM RATED.

NEW NUMBERED NOTES:

1. ELECTRICAL CONTRACTOR TO INSTALL NEW OF THE FOLLOWING ITEMS:
 - A. RECEPTACLES AND COVER PLATES SEE SPECIFICATIONS.
 - B. SWITCHES AND COVER PLATES SEE SPECIFICATIONS.
 - C. FAN CONTROLS. MATCH EXISTING.
 - D. LIGHT FIXTURES. WIRE TO OPERATE AS INDICATED ON THE DRAWINGS.
 - E. EMERGENCY LIGHTING AS INDICATED. WIRE NEW UNITS TO LIGHTING CIRCUIT AHEAD OF ANY SWITCHING.
2. NEW SWITCH LAYOUT. USE EXISTING ELECTRICAL LIGHTING CIRCUITS.
3. NEW SWITCH LOCATION. RUN NEW WIRES AS REQUIRED FOR CONTROL OF FIXTURES AS SHOWN.

GOVERNING CODES

2014 INDIANA BUILDING CODE
(IBC 2012 EDITION - WITH INDIANA AMENDMENTS)
2014 INDIANA FIRE CODE
(IFC 2012 EDITION - WITH INDIANA AMENDMENTS)
2012 INDIANA PLUMBING CODE
(IPC 2006 EDITION - WITH INDIANA AMENDMENTS)
2014 INDIANA MECHANICAL CODE
(IMC 2012 EDITION - WITH INDIANA AMENDMENTS)
2010 INDIANA ENERGY CONSERVATION CODE
(ANSI/ASHRAE 90.1 - 2007 EDITION - WITH INDIANA AMENDMENTS)
2009 INDIANA ELECTRICAL CODE
(NEC 2008 EDITION - WITH INDIANA AMENDMENTS)

GENERAL NOTES:

1. ALL CONTRACTORS AND SUB-CONTRACTORS SHALL REVIEW ALL DRAWINGS FOR WORK PERFORMED BY THAT CONTRACTOR.
2. ALL WALLS INDICATED ON THE ARCHITECTURAL PLANS AS FIRE RATED SHALL BE PROPERLY FIRE CAULKED FOR ALL PENETRATIONS.

THE CONTENTS OF THIS DOCUMENT ARE THE SOLE PROPERTY OF MICHAEL R. WALDBIESER ENGINEERING & CONSULTING, INC. AND MAY NOT BE REPRODUCED OR TRANSFERRED IN ANY WAY WITHOUT THE WRITTEN CONSENT OF MICHAEL R. WALDBIESER ENGINEERING & CONSULTING, INC.
ALL REPORTS, PLANS, SPECIFICATIONS, COMPUTER FILES, FIELD DATA, NOTES, AND OTHER DOCUMENTS AND INSTRUMENTS PREPARED BY MICHAEL R. WALDBIESER ENGINEERING & CONSULTING, INC. (DESIGN PROFESSIONAL) AS INSTRUMENTS OF SERVICE SHALL REMAIN THE PROPERTY OF MICHAEL R. WALDBIESER ENGINEERING & CONSULTING, INC. SHALL RETAIN ALL COMMON LAW, STATUTORY, AND OTHER RESERVED RIGHTS, INCLUDING THE COPYRIGHT THEREON. THIS STATEMENT SHALL NOT BE REMOVED FROM THIS DRAWING FOR ANY REASON.

DATE	REVISIONS	BY



BIRD GIBSON SPORTS CENTER
599 SOUTH TABORTOWN ROAD
TERRE HAUTE, INDIANA 47803
2026 BUILDING REMODEL PHASE 1

MICHAEL R. WALDBIESER
ENGINEER & CONSULTING, INC.
STRUCTURAL REMODELING, MECHANICAL & ELECTRICAL DESIGN

PHONE: (812) 232-6510

SYCAMORE BUILDING
19 SOUTH 66th STREET, SUITE 804
TERRE HAUTE, INDIANA 47807

SCALE: 1/8" = 1'-0"

DATE: 07-13-26

DRAWN BY: MRW

APPROVED BY: MRW

PROJECT: 25-24
FILE: PME #F

E1.0

SECTION 16000 - ELECTRICAL

PART 1: GENERAL. The General Conditions and other Contract Documents are hereby made a part of this Section to the same extent as if written out in full.

- 1.1 MANUFACTURE'S DESIGNATION
When manufacturers catalog numbers are given, they are for assistance to the bidder. In case of discrepancies in catalog numbers, the Contractor shall contact the Engineer of Record.
- 1.2 SUPERVISION
The Electrical Contractor shall, at all times throughout the construction period, maintain proper supervision of his employees, make orderly disposition of his materials, maintain high-class workmanship, systematically remove debris, cooperate fully with other contractors and subcontractors and avoid the creation of hazards to others on the job.
- 1.3 GUARANTEE
The Electrical Contractor shall make good any defects due to faulty material or workmanship; he shall correct any malfunction not due to misuse or abuse after date of acceptance which develops in his work, for a period on one (1) year from date of acceptance. The date of final payment shall be recognized as the date of acceptance.
- 1.4 EQUIPMENT MARKING AND PAINTING
All materials shall have card holders for circuit identification. Circuit legend shall be typewritten. Each outlet and switch shall have circuit identification marked on back of plate.
- 1.5 RULES, REGULATIONS AND PERMITS
All materials, workmanship, and installation shall conform to all local and state codes and federal O.S.H.A. standards. This Electrical Contractor shall, at his own expense, furnish all necessary permits and fees required by the Local Ordinances and by the State of Indiana for construction and inspection of work installed by him. Refer to drawings for specific enforceable Building Codes. Electrical contractor shall include in his bid all cost associated with obtaining service requirements shown on drawings.
- 1.6 TEMPORARY SERVICE
The Electrical Contractor shall furnish and maintain an adequate temporary electric service located at a convenient point, and shall also furnish and maintain adequate temporary lighting the full length of each corridor, with outlets for lights and plug-ins for power at approximately twenty (20) foot intervals. Adequate lighting shall be maintained throughout the building during normal working hours.
- 1.7 SYSTEM SCHEDULE
The Electrical Contractor shall furnish and install all systems as hereinafter specified and shown on the drawings.
- 1.8 SCOPE
The work intended under this DIVISION consists of the provision of all labor and material required for the installation of complete systems all in accordance with the specifications and the accompanying drawings. Each system shall be constructed to be complete after all components are in place, and all in working order as approved by the Engineer. Furnish and install all electrical systems specified herein and as shown on the drawings. All electrical work to be installed according to the National Electrical Code, current issue, and with service requirements of the Electric Company for this project.

PART 2: MATERIALS AND METHODS

- 2.1 PRODUCTS
ELECTRIC SERVICE: Service shall be as installed on the electrical drawings for voltage, phase and number of wires. This Contractor will extend branches as indicated.

FEEDER CIRCUITS: Feeder circuits shall be installed as shown on the drawings. All conduit shall be concealed except where necessary to use for connections to equipment and panel boards. Each feeder shall be protected with fuses and switches as shown on the drawings.

BRANCH CIRCUITS: Branch circuits shall be run from panels as shown with convenience outlet circuits. Outlets shall be grouped on circuits as shown on the drawings. PANELS: As indicated on the drawings. Panels and main breakers shall have integrated equipment short circuit rating as required by the local electrical utility and match the existing panels.

RECEPTACLES: See device specifications on drawings.

Backwiring is strictly prohibited. All wiring connections to be properly made at screw terminals with all units wrapped in electrical tape to cover all exposed terminals.

SWITCHES: See device specifications on drawings.

LIGHTING FIXTURES: See schedule on drawings. To be installed with a complete complement of lamps.

Before roughing-in outlets for various fixtures, this Contractor shall make certain that the fixture to be supplied is fitted with the proper hanging accessories to suit the purpose intended.

Flush type or recessed fixtures shall be installed with proper plaster rings or ceiling aligning devices for the ceilings to which they are to be attached, and shall be correctly spaced for symmetry with the surrounding ceiling pattern.

All recessed fixtures shall be light-tight under the surface trim; if not inherently leakproof by manufacturer's design, they shall be corrected by the use of adhering type gaskets which will not mar the ceiling surface.

Surface type fixtures shall have adequate knockouts, symmetrically spaced to insure access to the wiring space in the outlet above. Surface fixture bodies shall be effectively grounded by (1) fixture support, (2) two screws into the appliance or plaster cover, or (3) bare bonding wire from a ground bushing in the outlet box to the fixture body.

The Electrical Contractor shall furnish and install, complete with all glassware and lamps of sizes indicated by wattage, all fixtures as shown in the fixture schedule on the drawings.

All fixtures shall bear the Underwriters' Laboratories Label.

SAFETY SWITCHES: Provide proper size, heavy duty safety switches for motors and equipment where indicated and not in proximity of the panel from which fed.

Switches to be of the non-fused type. Switches on outdoor equipment shall have NEMA 3R enclosures.

MISCELLANEOUS WIRING: Provide and install service feeders for air conditioning units, exhaust and ventilating fans, water heater, etc. as indicated. Temperature control wiring for the 1st floor of the building shall be by the Electrical Contractor and installed in conduit. All temperature control wiring on the 2nd and 3rd floors shall be complete by the Mechanical Contractor. Control wiring connections to thermostats and mechanical units to be by the Mechanical Contractor.

All equipment provided for this project are to be as specified on the drawings. Other manufacturer's may be substituted as long as the product is an approved "equal" by the Engineer of Record.

DATA / INTERNET SYSTEMS: As detailed on the drawings by the E.C.

Provide boxes and conduit for use by Others as indicated on the drawings.

- FIRE ALARM SYSTEM: None.
- TELEPHONE SYSTEM: None.
- VIDEO SYSTEM: Complete by the Owner.
- GROUNDING: Grounding of all interior metallic water piping is to be per NEC. Grounding of all steel buildings is to be in strict accordance with NEC. Grounding of interior gas piping as required by Code.
- 2.2 WIRING PLAN
The Electrical Contractor may use the accompanying drawings as his working drawings. In this case, the general plan and circuiting shall be substantially followed except for deviations due to mechanical and structural interference.
- The Contractor shall, however, furnish additional drawings as hereinafter designated, or wherever directed, to bring out detail to a greater degree than that given on the accompanying drawings, or where alternate equipment, as furnished, does not fit the layout as planned on the original drawings.
- The Contractor may elect to furnish complete working drawings of his own. In this case, he shall furnish prints for approval before the work has begun. Any work installed before Engineer's approval of the drawings may be subject to rejection, if in the Engineer's opinion, it does not conform with the intent of these specifications and the accompanying drawings.
- 2.3 DRAWINGS
The Electrical Contractor shall furnish "Shop Drawings" in accordance with the requirements of DIVISION 1, GENERAL CONDITIONS and all amendments thereto. He shall obtain, ahead of job progress, the necessary manufacturer's drawings, wiring diagrams, and operating instructions for other Contractors equipment to which he is to connect. He shall also maintain a complete set of general, structural, electrical and mechanical drawings during the progress of the job. He shall also maintain a clean set of electrical drawings for record purposes, upon which he shall mark, legibly, all deviations from the Contract Documents. This set shall be turned over to the Engineer at the termination of the job for an "As Built" set.
- 2.4 FIELD LAYOUT
The intent of the drawings and these specifications is to cover circuiting, outlet location, and system coordination rather than to cover the exact location of each conduit; therefore, where interference with mechanical equipment and with the lines of other contractors are encountered, this Contractor shall at all times plan his work far enough in advance to avoid interfering with heavy equipment and large piping which cannot be readily shifted.
- 2.5 TYPE OF INSTALLATION
The basic wiring system shall be installed in accordance with the National Electrical Code. All wiring in the building shall be Type MC Cable or THHN CU in EMT Conduit. Shared neutrals are not allowed. All exposed electrical wiring inside the building shall be in EMT Conduit.
- 2.6 CONDUIT AND FITTINGS
Conduit for mains and feeders 2" IPS and larger shall be rigid galvanized heavy wall, threaded. All conduits exposed to weather, exposed through floors subject to hose cleaning and mopping, or exposed in earth filled spaces, shall be heavy wall galvanized. Other non-exposed conduits may be installed with either rigid conduit or electrical metallic tubing hereinafter referred to as EMT.
- Conduits laid underfloor indoors may be bare galvanized.
- In case of cast in slab work, all runs of EMT which may be bent or broken by removal of forms shall be carefully installed.
- All boxes shall be galvanized steel for use with MC Cable or EMT Conduit. Provide appropriate fire rated boxes in two hour fire rated walls on first floor. See Architectural drawings. Use galvanized steel boxes on 2nd and 3rd floor. Stagger boxes as required throughout building such that there is not more than one galvanized steel box per stud cavity. Blue plastic PVC boxes are prohibited on this project.
- 2.7 BASIC WIRING SYSTEM
The basic wiring system shall be fabricated as specified on the electrical drawings or in this specification. Wiring shall be sized as required to conform to the requirements of the latest National Electrical Code. All wire in conduit to be type THHN copper with all sizes larger than #8 AWG to be stranded.
- A. For wire #8 and smaller, provide solid wire; for wire larger than #8, provide stranded wire.
- B. Connectors shall be Thomas-Betts, Appleton, or Metalclics.
- C. Conductors shall be Triangle, Anaconda, Phelps Dodge, Columbia, Hatfield or Parantite and shall be sized per the requirements of NEC.
- No conductor to be smaller than #12 AWG.
- All wire in conduit to be THHN copper with all sizes larger than #8 AWG to be stranded.
- No conductor smaller than #12.
- Back-Wiring is strictly prohibited. All wiring connections to be properly made at screw terminals with all units wrapped in electrical tape to cover all exposed terminals.
- Power service to be as specified on the electrical drawings.
- The Contractor shall not charge as an extra, relocation of devices and fixtures, if new location is not over six feet from the original location.
- In any space used as "return air space" and indicated on the drawings, all wiring shall be in MC Cable or EMT conduit.
- Grounding of all interior metallic water piping to be per NEC.
- Exterior outlets and outlets indicated near sinks and lavatories shall be protected by approved "Ground Fault Circuit Interrupters" (GFI) typical throughout. GFIs installed where required by the National Electrical Code.
- 2.8 LOCATION OF OUTLETS AND EQUIPMENT CONNECTIONS
All outlets, as shown on the drawings, are intended to be in proper relative positions as far as symbol standards and the scale of the drawings permit. The exact positioning and final locations of these outlets, however, shall be as directed by the Engineer. This Contractor shall obtain the necessary horizontal and vertical dimensions of the outlets before roughing-in begins. This Contractor shall also obtain all necessary drawings and rough-in dimensions from the other contractors whose equipment is to be fitted.
- 2.9 CUTTING AND PATCHING
The Electrical Contractor shall do all the necessary cutting and fitting required for the proper installation of his work and shall repair any damage done by him or his workmen to the satisfaction of the Engineer.

PART 3: EXECUTION

All work on this project must be complete of all parts and supplies and hook-ups to make a complete operating job when the project is finished.

All equipment shall be installed in strict accordance with the manufacturer's installation instructions.

Verify voltage and amperage requirements for all equipment with Mechanical Contractor prior to start of the project.

Compaction of soil shall be as stated in the General Written Specifications for all trenching.

All trenching required for installation of products specified in this section of work shall be done by the Electrical Contractor. Backfilling after trenching shall be done in accordance with the General Written Specifications by the Electrical Contractor. After backfilling, the Electrical Contractor shall finish grade the area disturbed by the trenching to match that of the site prior to trenching.

END OF SECTION

GENERAL MEP NOTE:

PLUMBING, MECHANICAL, AND ELECTRICAL CONTRACTORS TO ENSURE COORDINATION OF EQUIPMENT AND MATERIALS INSTALLATION WITH OTHER BUILDING COMPONENTS. ALL WORK SHALL BE DONE IN ACCORDANCE WITH STATE, COUNTY, CITY BUILDING REGULATIONS AND CODES AS WELL AS INDUSTRY STANDARD PRACTICE. THESE REQUIREMENTS ARE CONSIDERED PART OF THE PLANS AND SPECIFICATIONS AND SHALL PREVAIL SHOULD THEY DIFFER FROM THE PLANS AND SPECIFICATIONS, PRIOR TO BID SUBMISSION, THE CONTRACTOR SHOULD DIRECT THE ENGINEER'S ATTENTION TO ANY DISCREPANCY. SHOULD THE PRIME CONTRACTOR NOT SO NOTIFY THE ENGINEER, THE CONTRACTORS SHALL FULLY COMPLY WITHOUT CLAIM FOR EXTRA COSTS. REFER TO DRAWINGS FOR GOVERNING BUILDING CODES.

LIGHT FIXTURE SCHEDULE							
MARK	MFG.	MODEL	DESCRIPTION	VOLTAGE	INPUT WATTS	LAMPS	REMARKS
A1	COLUMBIA LIGHTING	CLT24-LSCS-EDD @ HIGH, 40K	CENTER LENS TROFFER WITH SWITCHABLE LUMENS AND CCT	120 VOLT	45 WATTS 6150 LUMENS	4000K	-
A2	COLUMBIA LIGHTING	CLT24-LSCS-EDD @ MED, 40K	CENTER LENS TROFFER WITH SWITCHABLE LUMENS AND CCT	120 VOLT	35 WATTS 5150 LUMENS	4000K	-
A3		CLT24-LSCS-EDD @ LOW, 40K	CENTER LENS TROFFER WITH SWITCHABLE LUMENS AND CCT	120 VOLT	25 WATTS 3900 LUMENS	4000K	-
B1	COLUMBIA LIGHTING	CBT24-X-LSCS-EDD @ MED, 40K	BACK-LIT TROFFER WITH SWITCHABLE LUMENS AND CCT	120 VOLT	38 WATTS 5246 LUMENS	4000K	-
B2	COLUMBIA LIGHTING	CBT24-X-LSCS-EDD @ LOW, 40K	BACK-LIT TROFFER WITH SWITCHABLE LUMENS AND CCT	120 VOLT	26 WATTS 3775 LUMENS	4000K	-
C1	COLUMBIA LIGHTING	CBT22-X-LSCS-EDD @ LOW, 40K	BACK-LIT TROFFER WITH SWITCHABLE LUMENS AND CCT	120 VOLT	24 WATTS 2849 LUMENS	4000K	-

LIGHT FIXTURE SCHEDULE							
MARK	MFG.	MODEL	DESCRIPTION	VOLTAGE	INPUT WATTS	LAMPS	REMARKS
EXM1	DUAL-LITE	EVC-U-G-W-D4-I WITH DUAL-LITE PGR REMOTE HEAD.	EVC SERIES LED THERMOPLASTIC EMERGENCY/EXIT COMBO WITH SELF-DIAGNOSTICS. WHITE IN COLOR.	120 VOLT	1.65 WATTS	2 - 10W LED	-
EXM2	DUAL-LITE	EVC-U-G-B-D4-I WITH DUAL-LITE PGR REMOTE HEAD.	EVC SERIES LED THERMOPLASTIC EMERGENCY/EXIT COMBO WITH SELF-DIAGNOSTICS. BLACK IN COLOR.	120 VOLT	1.65 WATTS	2 - 10W LED	-
EXM3	DUAL-LITE	EVC-U-G-W-I	EVC SERIES LED THERMOPLASTIC EMERGENCY/EXIT COMBO WITH SELF-DIAGNOSTICS. WHITE IN COLOR.	120 VOLT	1.65 WATTS	2 - 10W LED	-
EXM4	DUAL-LITE	EVC-U-G-B-I	EVC SERIES LED THERMOPLASTIC EMERGENCY/EXIT COMBO WITH SELF-DIAGNOSTICS. BLACK IN COLOR.	120 VOLT	1.65 WATTS	2 - 10W LED	-
EX1	DUAL-LITE	EVE-U-G-W-E-I	EVE SERIES LED THERMOPLASTIC EXIT UNIT WITH SELF-DIAGNOSTICS. WHITE IN COLOR.	120 VOLT	2.0 WATTS	-	-
EX2	DUAL-LITE	EVE-U-G-B-E-I	EVE SERIES LED THERMOPLASTIC EXIT UNIT WITH SELF-DIAGNOSTICS. BLACK IN COLOR.	120 VOLT	2.0 WATTS	-	-
EM1	DUAL-LITE	EV-2-I	EV SERIES LED THERMOPLASTIC EMERGENCY LIGHT. WHITE IN COLOR WITH SELF-DIAGNOSTICS	120 VOLT	1.1 WATTS	2 - 10W LED	-
EM2	DUAL-LITE	EV-2-I-B	EV SERIES LED THERMOPLASTIC EMERGENCY LIGHT. BLACK IN COLOR WITH SELF-DIAGNOSTICS	120 VOLT	1.1 WATTS	2 - 10W LED	-

ELECTRICAL DEVICE SCHEDULE	
1	PASS & SEYMOUR CSB20AC1 - SINGLE POLE SWITCH
2	PASS & SEYMOUR CSB20AC2 - DOUBLE POLE SWITCH
3	PASS & SEYMOUR CSB20AC3 - THREE WAY SWITCH
3	PASS & SEYMOUR CSB20AC4 - FOUR WAY SWITCH
3	COMPATIBLE DIMMER FOR SPECIFIED LIGHT FIXTURES
3	PASS & SEYMOUR VSP200 OCCUPANCY SENSOR
3	COMPATIBLE TIMER FOR OPERATION REQUIRED WITH ADJUSTABLE OFF TIME
3	PASS & SEYMOUR CSB20AC4 - GAS FURNACE CONNECTION
3	PASS & SEYMOUR CR20 RECEPTACLE
3	PASS & SEYMOUR CR20 QUAD
3	PASS & SEYMOUR CR20 RECEPTACLE - MOUNT ABOVE BACKSPLASH
3	PASS & SEYMOUR CR20 RECEPTACLE FOR DEDICATED COPIER
3	PASS & SEYMOUR CR20 RECEPTACLE CEILING MOUNTED
3	MICROWAVE OVEN CONNECTION AS REQUIRED
3	DISH WASHER CONNECTION AS REQUIRED
3	PASS & SEYMOUR CR20 RECEPTACLE W/ FLUSH MOUNTED COVER
3	PASS & SEYMOUR CR20 WITH WEATHERPROOF COVER
3	PASS & SEYMOUR CR20 FOR TV - HEIGHT DIRECTED BY OWNER A.F.F.
3	PASS & SEYMOUR CR20 RECEPTACLE SURFACE MOUNTED WITH WIREMOLD METAL RACEWAYS AND BOXES. COLOR BY OWNER
3	PASS & SEYMOUR 9300 RECEPTACLE - HOSPITAL GRADE
3	PASS & SEYMOUR USB CHARGING/RECEPTACLE. ARTRUSB286ACV4. COLOR BY OWNER
3	PASS & SEYMOUR TR20 - TAMPER RESISTANT
3	PASS & SEYMOUR 5352 TVSS/ISOLATED GROUND RECEPTACLE
3	PASS & SEYMOUR 2095T GFCI RECEPTACLE - TAMPER RESISTANT
3	PASS & SEYMOUR 2095T GFCI RECEPTACLE - MOUNT ABOVE BACKSPLASH
3	PASS & SEYMOUR 2095T GFCI RECEPTACLE W/ WEATHERPROOF COVER
3	PASS & SEYMOUR 3890 DR 3894 50 AMP FLUSH MOUNTED RANGE RECEPTACLE COORDINATE WITH OWNER EQUIPMENT
3	PASS & SEYMOUR 3860 DR 3864 30 AMP FLUSH MOUNTED DRYER RECEPTACLE COORDINATE WITH OWNER EQUIPMENT
TTB	TELEPHONE TERMINAL BOARD LOCATION E.G. TO PROVIDE AND INSTALL 48"x48" 3/4" PLYWOOD WALL MOUNTED
3	GARBAGE DISPOSAL CONNECTION
3	FURNACE BY MC. WIRED BY E.C.
3	MOTOR CONNECTION AS NOTED BY E.C.
3	PASS & SEYMOUR CSB1000 DUAL TECHNOLOGY CEILING OCCUPANCY SENSOR WITH CSBP210 120 VOLT POWER PACK AS REQUIRED
3	EXHAUST FAN BY MC. CONTROLLED AS SHOWN.

ELECTRICAL DEVICE NOTES:

- COLOR OF DEVICES AS SELECTED BY THE OWNER.
- WALL PLATES SHALL BE PASS & SEYMOUR THERMOSET PLASTIC - STANDARD SIZE IN STORAGE ROOM AND RESTROOM.
- ALL OTHERS SHALL BE GALVANIZED STEEL.
- FIELD COORDINATE DEVICE LOCATION WITH ARCHITECTURAL CASEWORK DRAWINGS.
- DEVICES AS LISTED OR APPROVED EQUALS.

DATE	REVISIONS	BY



BIRD GIBSON SPORTS CENTER
599 SOUTH TABORTOWN ROAD
TERRE HAUTE, INDIANA 47803
2026 BUILDING REMODEL PHASE 1

MICHAEL R. WALDBIESER
ENGINEER & CONSULTING, INC.
STRUCTURAL, MECHANICAL, ELECTRICAL, PLUMBING
SYCAMORE BUILDING
19 SOUTH 66TH STREET, SUITE 804
TERRE HAUTE, INDIANA 47807
PHONE: (812) 232-0510

SCALE: NONE	DATE: 07-13-26	DRAWN BY: MRW	APPROVED BY: MRW
-------------	----------------	---------------	------------------

PROJECT: 25-24
FILE: PME #F

E2.0

GOVERNING CODES

- 2014 INDIANA BUILDING CODE
(IBC 2012 EDITION - WITH INDIANA AMENDMENTS)
- 2014 INDIANA FIRE CODE
(IFC 2012 EDITION - WITH INDIANA AMENDMENTS)
- 2012 INDIANA PLUMBING CODE
(IPC 2006 EDITION - WITH INDIANA AMENDMENTS)
- 2014 INDIANA MECHANICAL CODE
(IMC 2012 EDITION - WITH INDIANA AMENDMENTS)
- 2010 INDIANA ENERGY CONSERVATION CODE
(ANSI/ASHRAE 90.1 - 2007 EDITION - WITH INDIANA AMENDMENTS)
- 2009 INDIANA ELECTRICAL CODE
(NEC 2008 EDITION - WITH INDIANA AMENDMENTS)

GENERAL NOTES:

- ALL CONTRACTORS AND SUB-CONTRACTORS SHALL REVIEW ALL DRAWINGS FOR WORK PERFORMED BY THAT CONTRACTOR.
- ALL WALLS INDICATED ON THE ARCHITECTURAL PLANS AS FIRE RATED SHALL BE PROPERLY FIRE CAULKED FOR ALL PENETRATIONS.

THE CONTENTS OF THIS DOCUMENT ARE THE SOLE PROPERTY OF MICHAEL R. WALDBIESER ENGINEERING & CONSULTING, INC. AND MAY NOT BE REPRODUCED OR TRANSFERRED IN ANY WAY WITHOUT THE WRITTEN CONSENT OF MICHAEL R. WALDBIESER ENGINEERING & CONSULTING, INC.

ALL REPORTS, PLANS, SPECIFICATIONS, COMPUTER FILES, FIELD DATA, NOTES, AND OTHER DOCUMENTS AND INSTRUMENTS PREPARED BY MICHAEL R. WALDBIESER ENGINEERING & CONSULTING, INC. (DESIGN PROFESSIONAL) AS INSTRUMENTS OF SERVICE SHALL REMAIN THE PROPERTY OF MICHAEL R. WALDBIESER ENGINEERING & CONSULTING, INC. MICHAEL R. WALDBIESER ENGINEERING & CONSULTING, INC. SHALL RETAIN ALL COMMON LAW, STATUTORY, AND OTHER RESERVED RIGHTS, INCLUDING THE COPYRIGHT THERE TO. THIS STATEMENT SHALL NOT BE REMOVED FROM THIS DRAWING FOR ANY REASON.